

October 10, 2014

**BOARD OF COUNTY COMMISSIONERS
ORANGE COUNTY, FLORIDA
ADDENDUM NO. 4 / IFB Y15-703-EZ**

New Bid Opening Date: October 21, 2014

**FIRE ALARM REPLACEMENTS AT MARKS STREET SENIOR CENTER, ORANGE COUNTY
MEDICAL CLINIC AND ORANGE COUNTY SHERIFF FLEET BUILDING**

This Addendum is hereby incorporated into the bid documents of the project referenced above. The following items are clarifications, corrections, additions, deletions and/or revisions to and shall take precedence over the original documents. Additions are indicated by underlining, deletions are indicated by ~~striketrough~~.

1. The bid opening date is hereby changed from ~~October 14, 2014~~ to October 21, 2014.
2. Drawing Sheet No. E-1.B is included with this Addendum as it was left out of Addendum #3.
3. **All other terms, conditions and specifications remain the same.**
4. a. **The Proposer shall acknowledge receipt of this addendum by completing the applicable section in the solicitation or by completion of the acknowledgement information on the addendum. Either form of acknowledgement must be completed and returned not later than the date and time for receipt of proposals.**


b. **Receipt acknowledged by:**

_____ **Authorized Signature** _____ **Date Signed**

_____ **Title**

_____ **Name of Firm**

MATERN PROFESSIONAL ENGINEERING PLOT DATE: 9/25/2014 4:03:01 PM FILENAME: J:\2013\2013-010_OC_Medical_Clinic_101_S_Westmoreland_Drive_Replace_Existing_Fire_Alarm\CAD_Dobbs_OC_Medical_Clinic_101_S_Westmoreland_Drive_Replace_Existing_Fire_Alarm\CAD_Dobbs_OC_Medical_Clinic_101_S_Westmoreland_Drive_Replace_Existing_Fire_Alarm_1.B.dwg
 CREATE DATE: 9/16/2014 2:06:52 PM LAST SAVED: 9/16/2014 2:06:52 PM JUST SAVED BY: MDOOSTNER

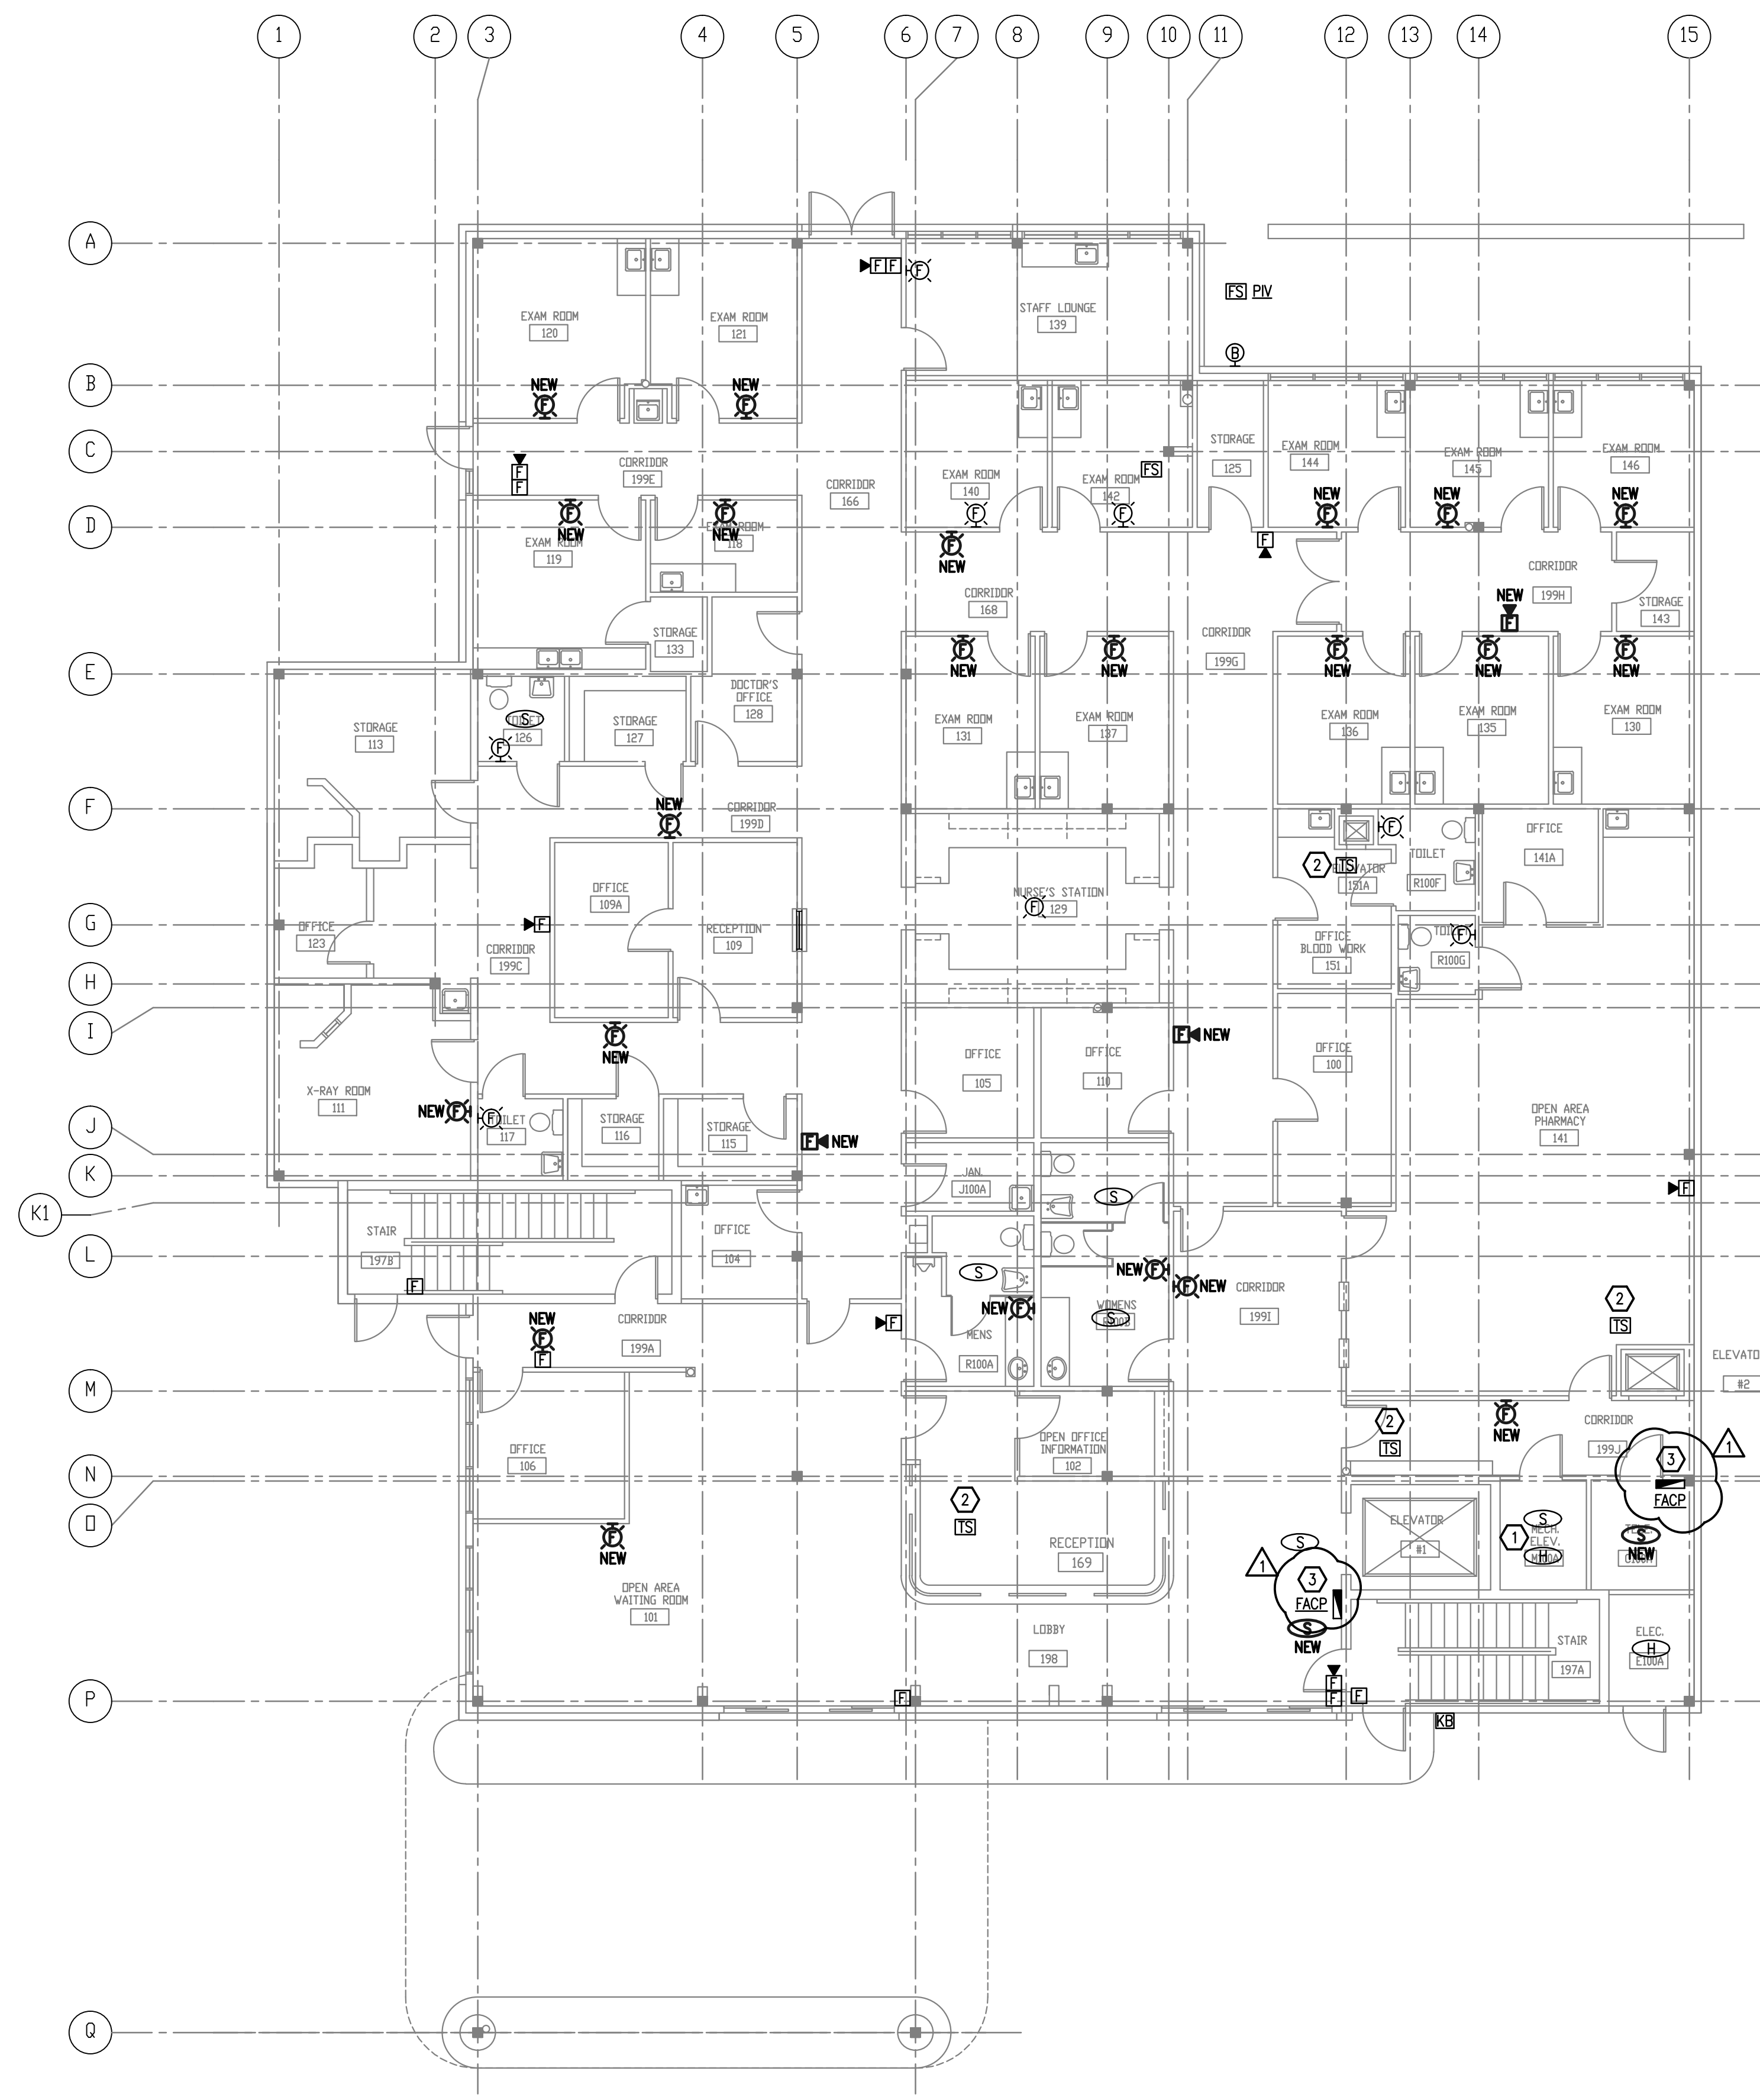

FIRST FLOOR PLAN - FIRE ALARM
SCALE: 1/8"=1'-0"

GENERAL NOTES

- REFER TO SHEET E-0.B FOR SCOPE OF WORK, SYMBOL LEGEND AND GENERAL NOTES.
- STROBE DEVICES SHALL BE SYNCHRONIZED IN AREAS WHERE MORE THAN ONE STROBE IS VISIBLE PER NFPA 72 - 7.5.4.3.2.

KEY NOTES

- CONTRACTOR SHALL VERIFY AND INSTALL ALL NEW FIRE ALARM DEVICES, WIRING, ETC. ASSOCIATED WITH ELEVATOR OPERATION AS REQUIRED.
- SPRINKLER SYSTEM TAMPER SWITCH LOCATED ABOVE CEILING.
- ORANGE COUNTY FACILITIES MAINTENANCE HAS REQUESTED THAT THE FIRE ALARM CONTROL PANEL BE INSTALLED AT A MORE ACCESSIBLE LOCATION. INSTALL THE NEW FACP IN THE LOBBY TO REPLACE THE EXISTING FIRE ALARM ANNUNCIATOR PANEL.

CONSTRUCTION NOTES

- ALL FIRE ALARM DEVICES SHOWN ON THIS PLAN ARE EXISTING TO BE REPLACED WITH NEW DEVICES UNLESS OTHERWISE INDICATED. ANY NEW DEVICES TO BE INSTALLED AT NEW LOCATIONS ARE MARKED AS "NEW".
- MOST OF THE EXISTING WALL MOUNTED DEVICES AT PRESENT LOCATIONS DO NOT MEET CODE REQUIRED MOUNTING HEIGHTS. THE APPROVED METHOD FOR INSTALLING A NEW REPLACEMENT DEVICE IS TO INSTALL IT IMMEDIATELY NEXT TO THE EXISTING DEVICE AND AT THE CODE COMPLIANT ELEVATION. THIS METHOD ALSO ALLOWS FOR THE BEST INSTALLATION OF A NEW SYSTEM WHILE THE EXISTING REMAINS OPERATIONAL. EXISTING RECESSED WALL OUTLET BOXES SHALL HAVE BLANK COVERS INSTALLED AND PAINTED TO MATCH WALL.

MATERN PROFESSIONAL ENGINEERING
 MEP/F/P Engineering
 Consultants - A Solutions Based Firm
 ORLANDO | Fort Myers | Jacksonville | Tampa
 Matern Professional Engineering, Inc
 130 Candace Drive
 Maitland, FL 32751-3331
 PHONE (407) 740-0020 FAX (407) 740-0365
 THIS DRAWING IS THE PROPERTY OF MATERN PROFESSIONAL ENGINEERING, INC. UNLESS OTHERWISE PROVIDED BY THE CONTRACT, THE CONTENTS OF THIS DRAWING SHALL NOT BE TRANSMITTED TO ANY OTHER PARTY EXCEPT AS AGREED TO BY THE ENGINEER.
 ENG. BUS. No. EB-0005096 CERT. OF AUTH. No. 5096

ORANGE COUNTY MEDICAL CLINIC FIRE ALARM REPLACEMENT

AUGUSTO E. BOBES JR., P.E.
 FLORIDA P.E. # 39410
BOBES ASSOCIATES CONSULTING ENGINEERS
 150 CIRCLE DRIVE, MAITLAND, FL 32751
 TELEPHONE: 407.628.0882
 E-MAIL: INFO@BOBES.COM
 FLORIDA STATE P.E. NUMBER: 5131

Revisions

No.	Date	Description
1	9/25/14	ADDENDUM #1

Key Plan

MPE PROJ#: 2013-010
Designed By: WMC
Drawn By: WMC
Checked By: ABJr
Issue Date: 06/17/14
Drawing Scale: 1/8" = 1'-0"
Drawing Title:

1ST FLOOR PLAN FIRE ALARM

BID DOCUMENTS

Drawing No.
E-1.B