



REVISIONS		GTC Engineering Corporation		ORANGE COUNTY PUBLIC WORKS		COLLIER BLVD.		SHEET NO.
DATE	DESCRIPTION	DATE	DESCRIPTION	GTC PROJECT NO.	LITTLE EGYPT SIDEWALK IMPROVEMENTS	OCPW PROJECT NO.	PLAN AND PROFILE	
				FLO 23.02		0193	STA. 10+00.00 TO STA. 15+20.00	20

FILE: H:\Jobs\F1023.02-LittleEgypt\roadway\PLPRRD01.dgn
 DATE: 2/16/2018 8:40:23 AM

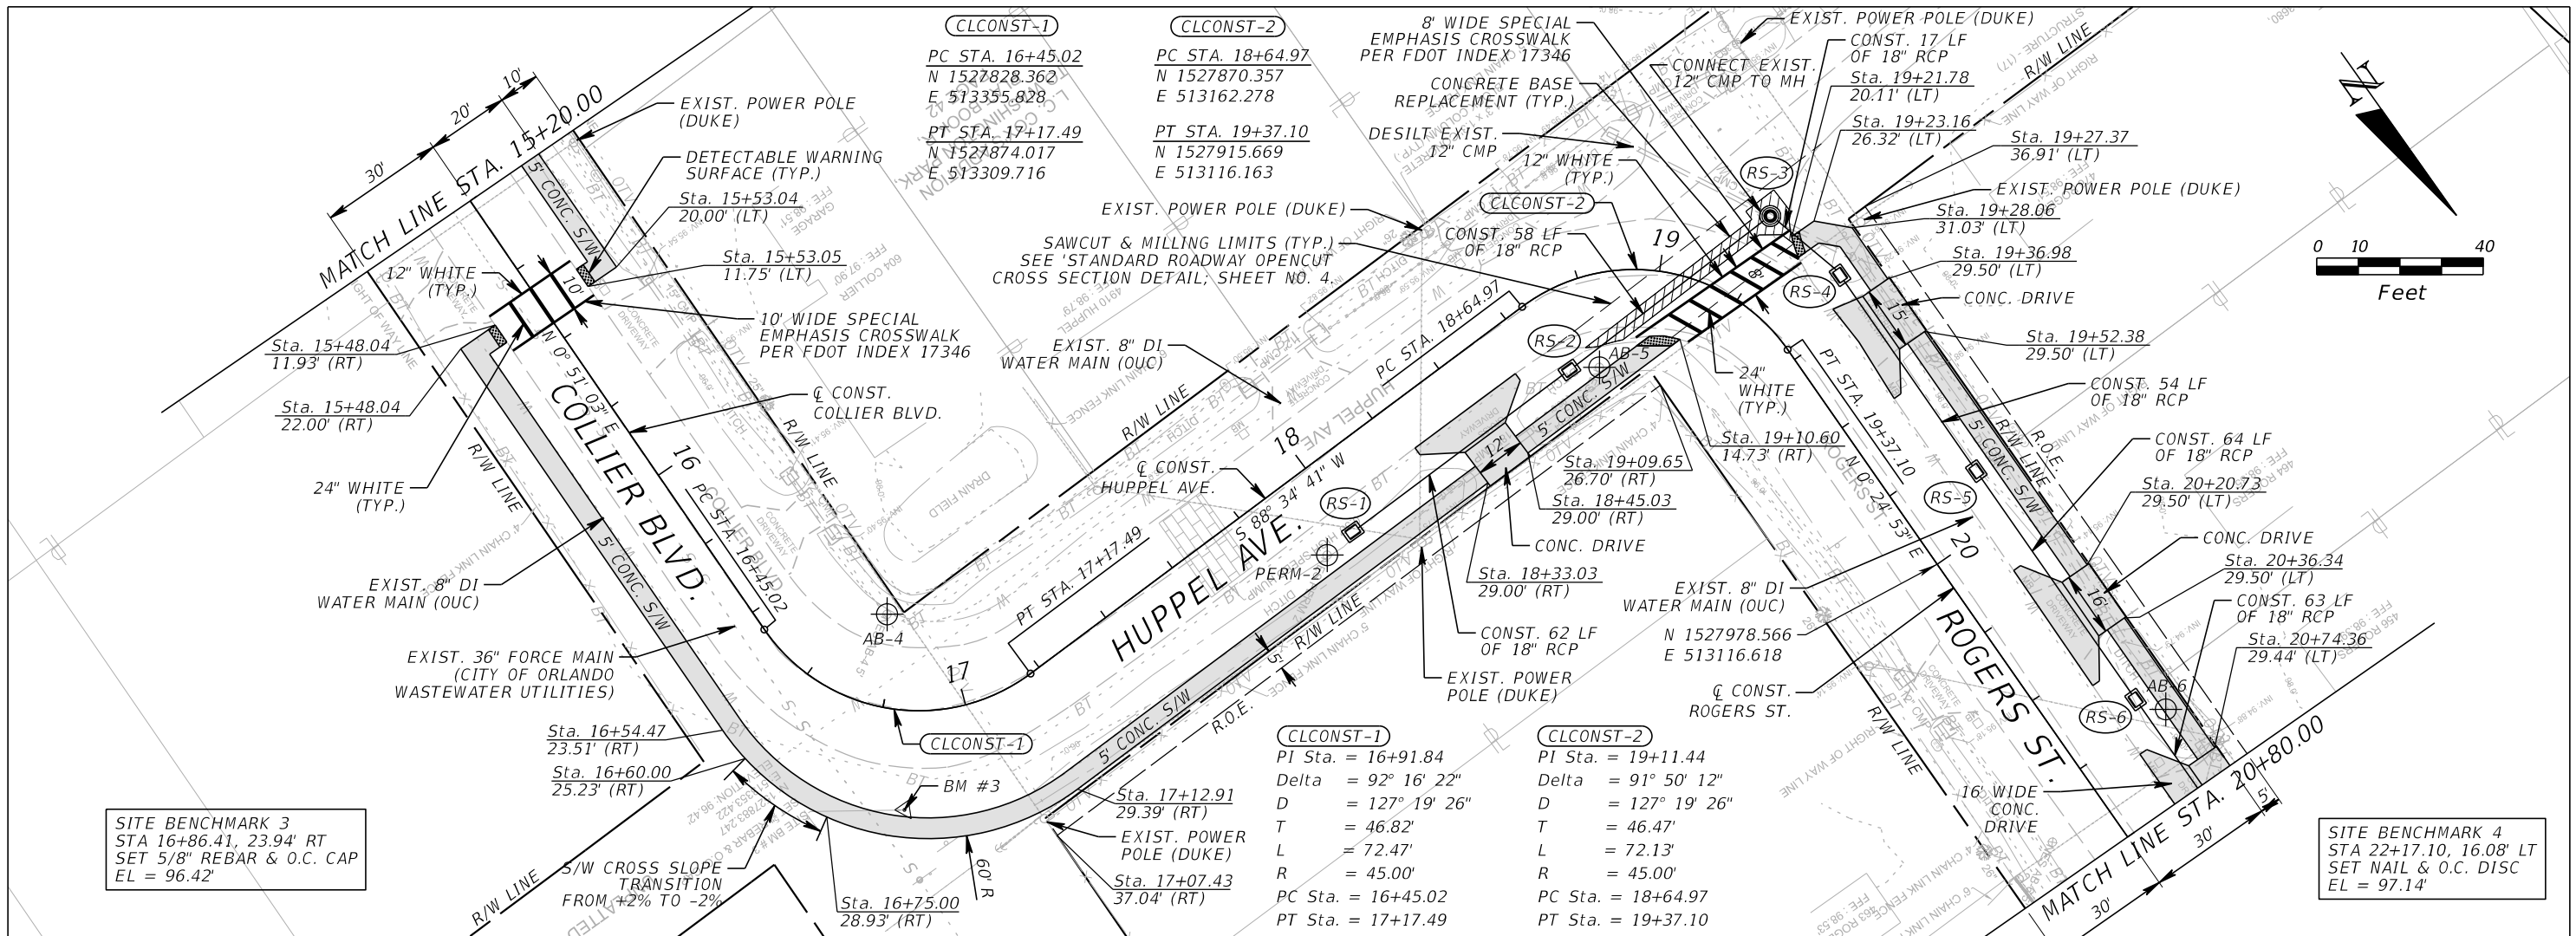



SITE BENCHMARK 3
 STA 16+86.41, 23.94' RT
 SET 5/8" REBAR & O.C. CAP
 EL = 96.42'

SITE BENCHMARK 4
 STA 22+17.10, 16.08' LT
 SET NAIL & O.C. DISC
 EL = 97.14'

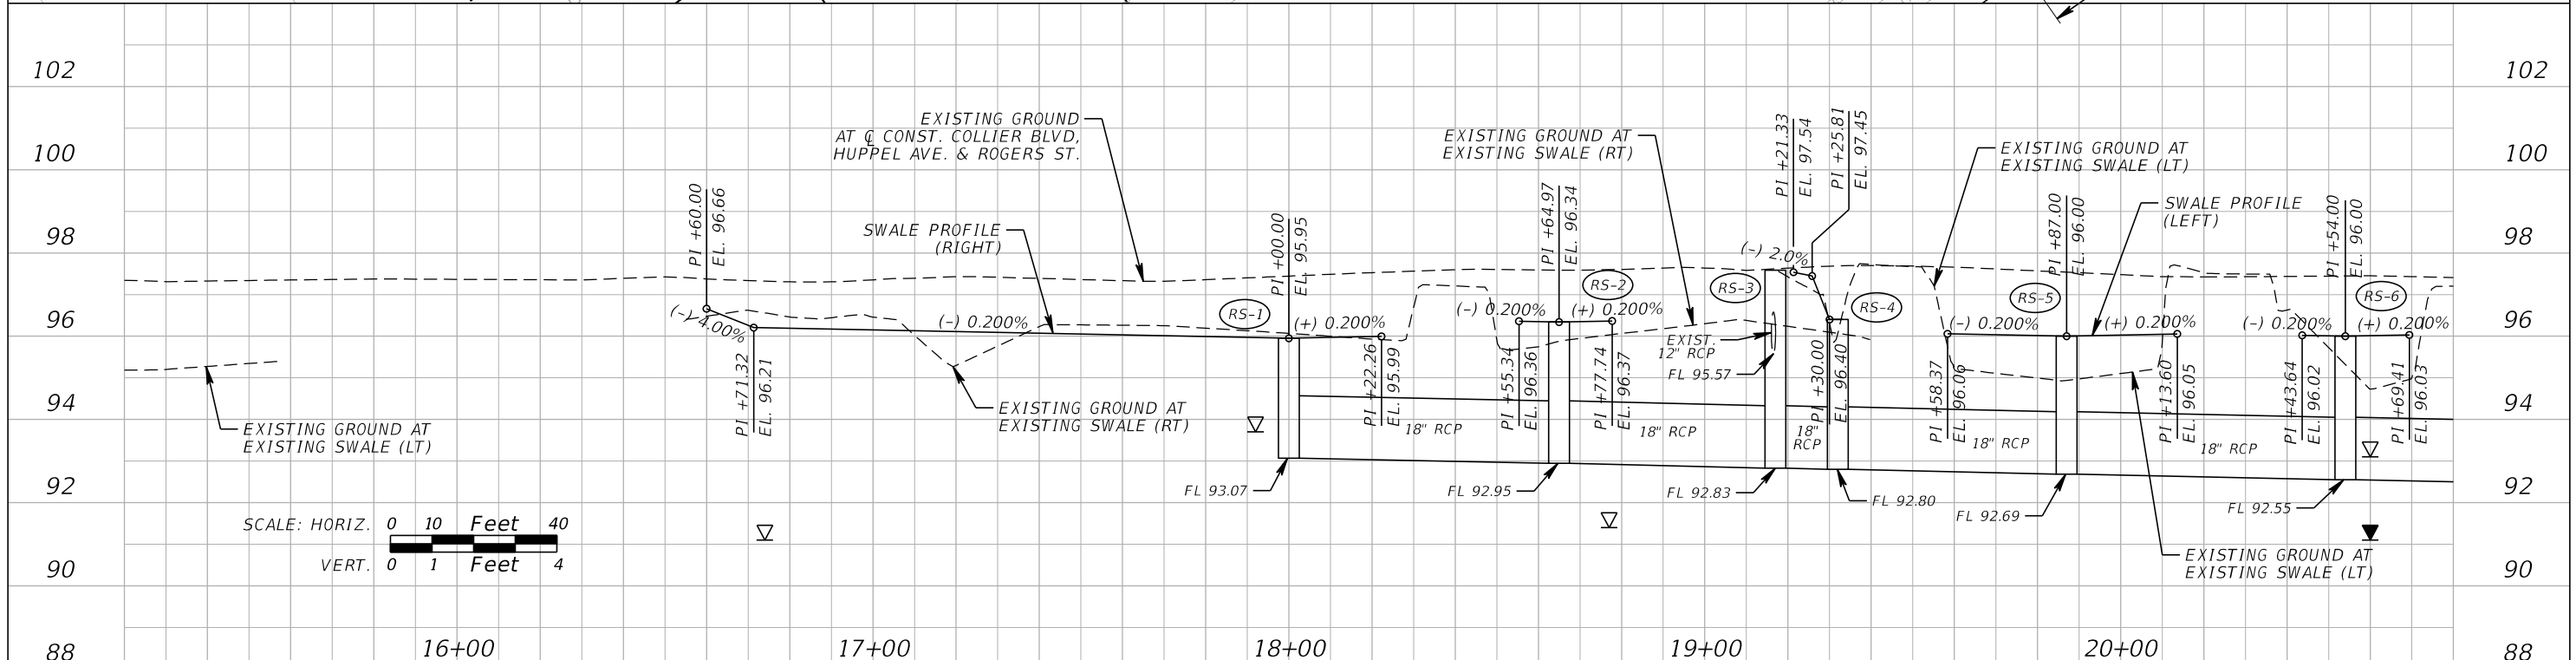

REVISIONS		GTC Engineering Corporation		ORANGE COUNTY PUBLIC WORKS		COLLIER BLVD., HUPPEL AVE. & ROGERS ST. PLAN AND PROFILE STA. 15+20.00 TO STA. 20+80.00		SHEET NO.
DATE	DESCRIPTION	DATE	DESCRIPTION	GTC PROJECT NO.	LITTLE EGYPT SIDEWALK IMPROVEMENTS	OCPW PROJECT NO.		
				FLO 23.02		0193		21

FILE: H:\Jobs\FLO23.02-LittleEgypt\roadway\PLPRD02.dgn
 DATE: 5/8/2018 8:27:24 AM

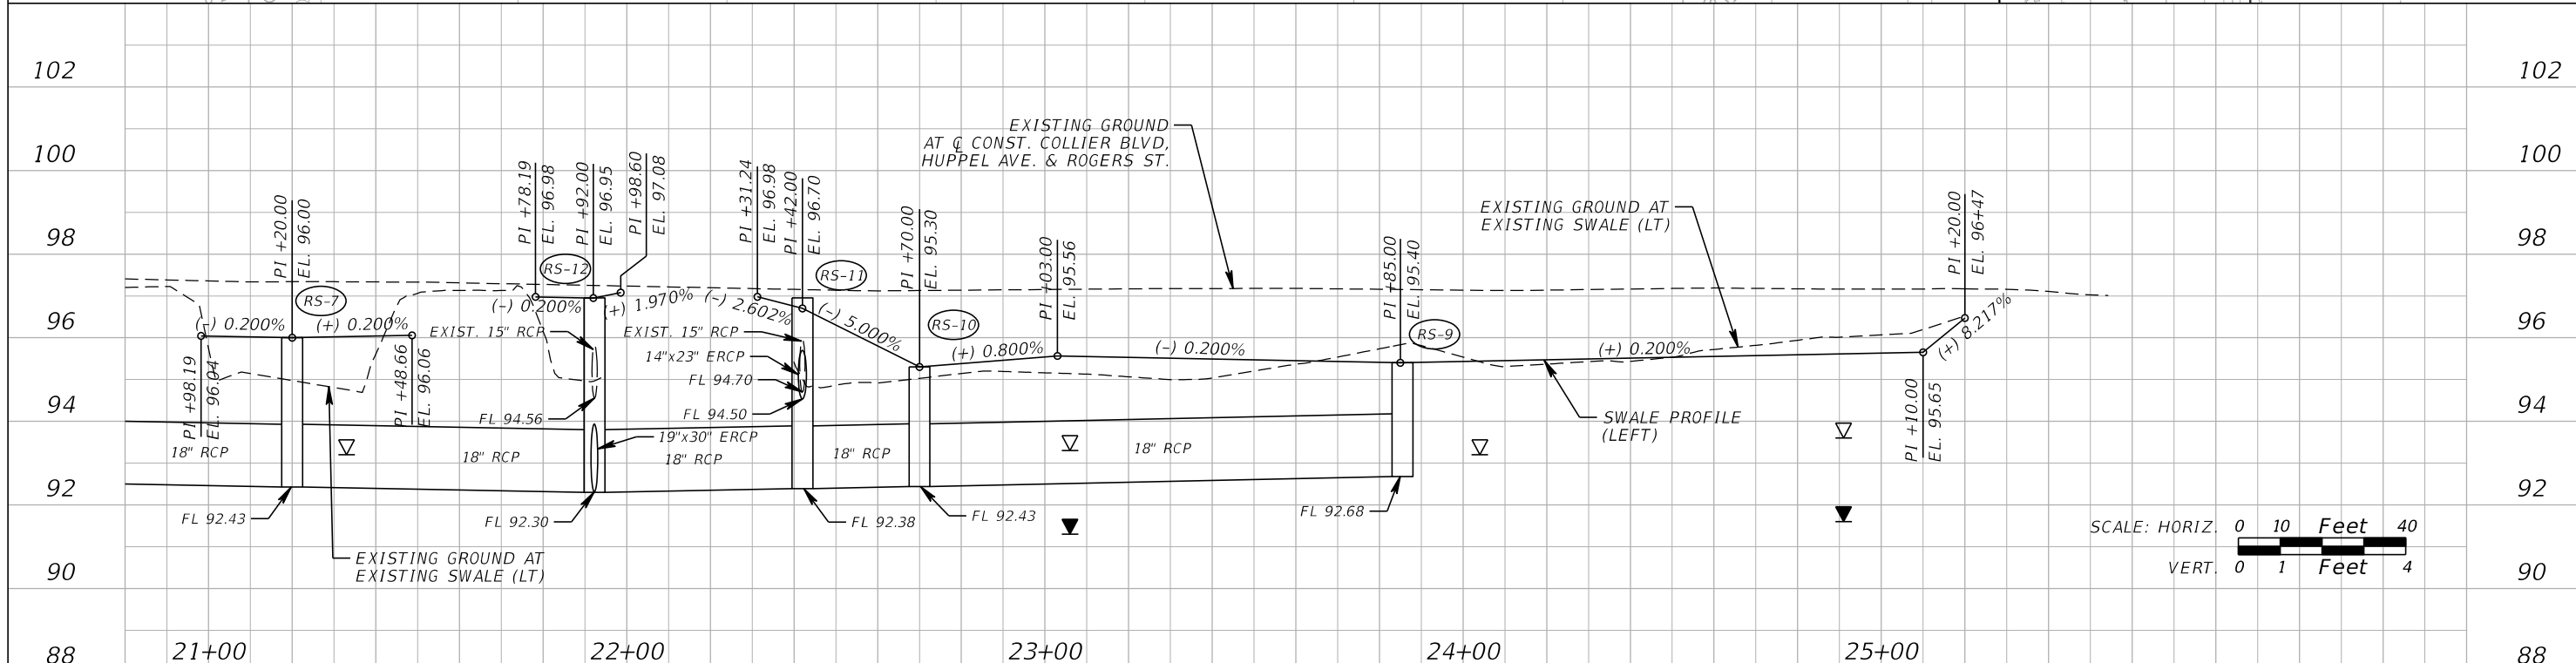
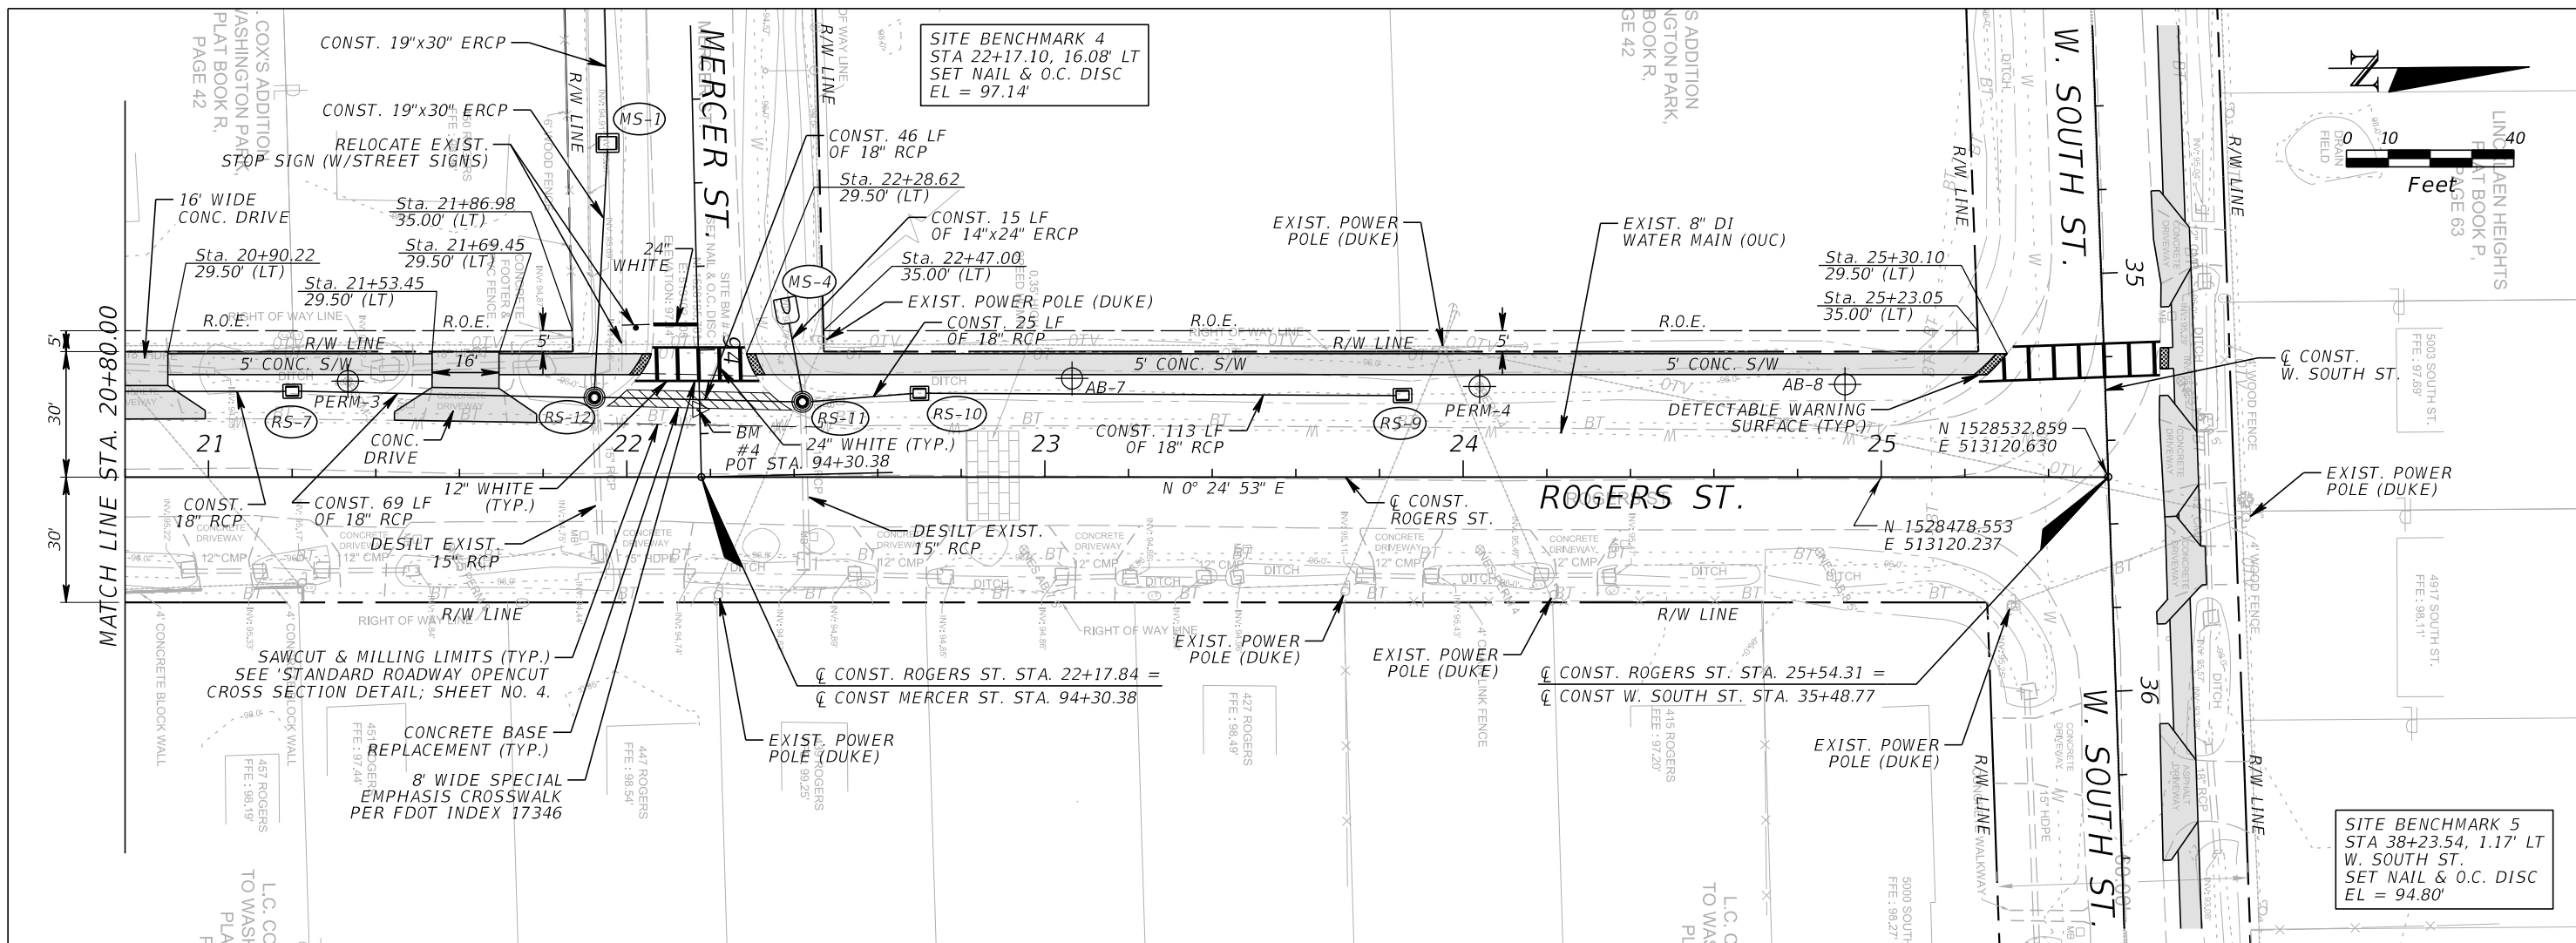


REVISIONS		GTC Engineering Corporation		ORANGE COUNTY PUBLIC WORKS		ROGERS ST.		SHEET NO.
DATE	DESCRIPTION	DATE	DESCRIPTION	GTC PROJECT NO.	LITTLE EGYPT SIDEWALK IMPROVEMENTS	OCPW PROJECT NO.	PLAN AND PROFILE	
				FLO 23.02		0193	STA. 20+80.00 TO STA. 25+54.31	22

SITE BENCHMARK 4
STA 22+17.10, 16.08' LT
SET NAIL & O.C. DISC
EL = 97.14'

SITE BENCHMARK 5
STA 38+23.54, 1.17' LT
W. SOUTH ST.
SET NAIL & O.C. DISC
EL = 94.80'


FILE: H:\Jobs\FLO23.02-LittleEgypt\roadway\PLPRD03.dgn
DATE: 5/8/2018 8:27:26 AM

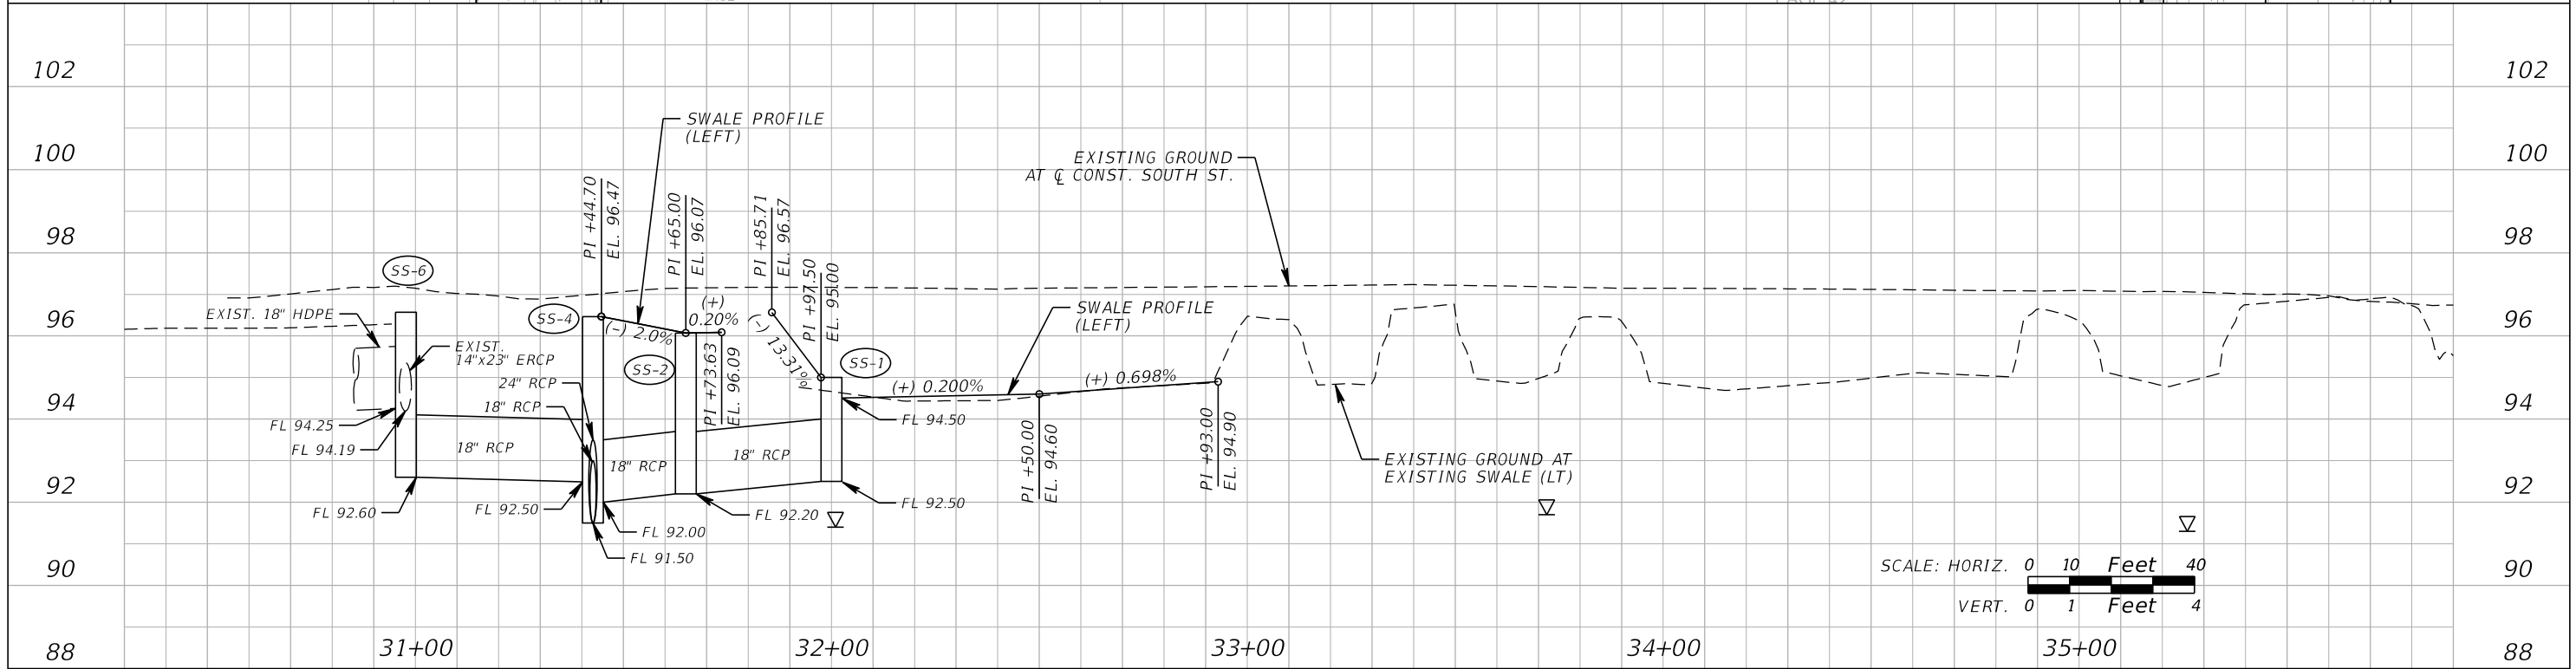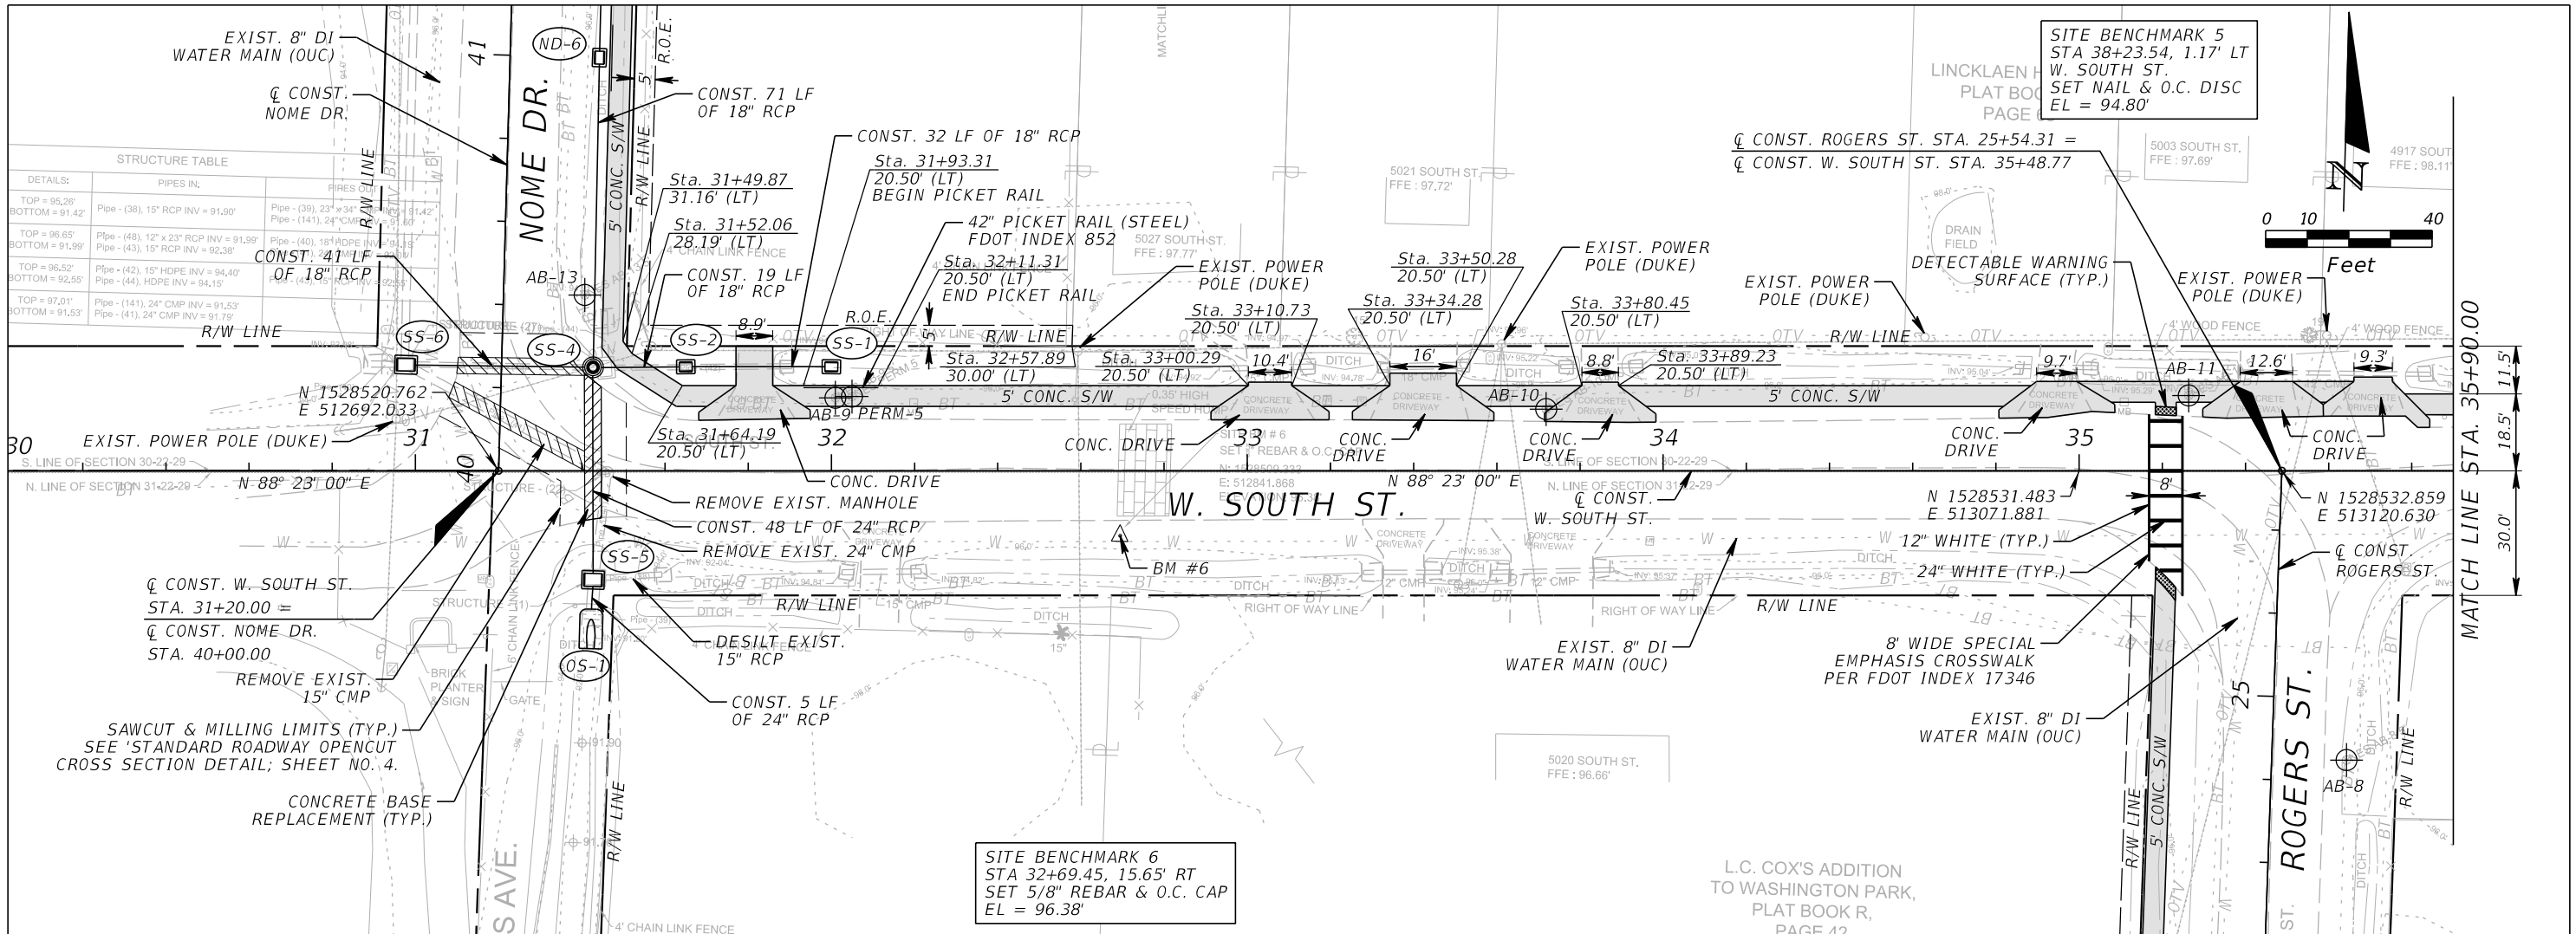

REVISIONS		GTC Engineering Corporation		ORANGE COUNTY PUBLIC WORKS		W. SOUTH ST.		SHEET NO.
DATE	DESCRIPTION	DATE	DESCRIPTION	GTC PROJECT NO.	LITTLE EGYPT SIDEWALK IMPROVEMENTS	OCPW PROJECT NO.	PLAN AND PROFILE	
				FLO 23.02		0193	STA. 31+20.00 TO STA. 35+90.00	23


CONTACT INFORMATION:
 GTC Engineering Corporation: 98 South Semoran Blvd, Orlando, FL 32807, Phone Number - 407.380.0402
 Claude L. Cassagnol, P.E.: P.E. Number 35490
 Certificate of Authorization Number 6758

FILE: H:\Jobs\FLO23.02-LittleEgypt\roadway\PLPRRD04.dgn
DATE: 5/8/2018 2:43:04 PM

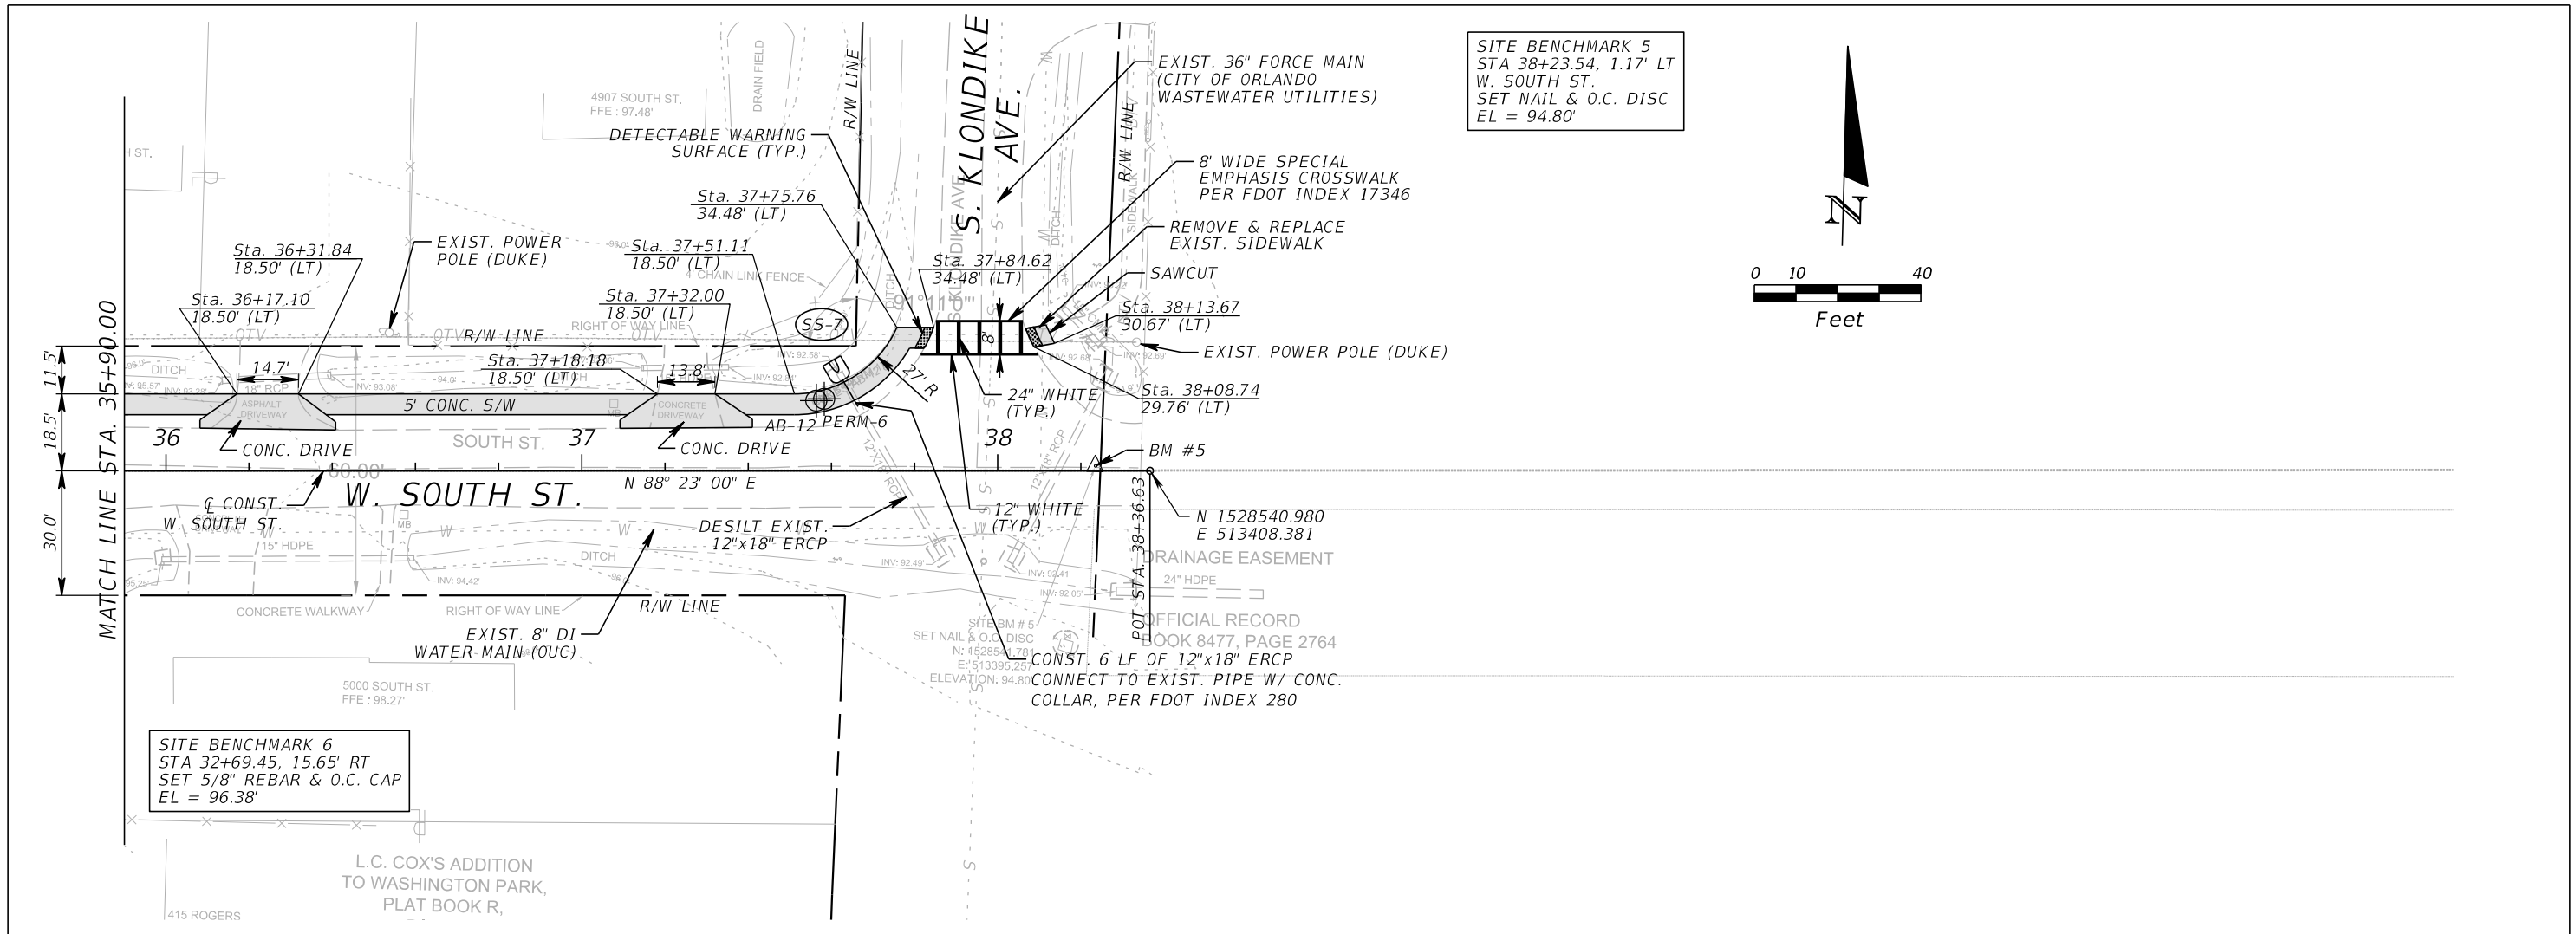

SITE BENCHMARK 5
 STA 38+23.54, 1.17' LT
 W. SOUTH ST.
 SET NAIL & O.C. DISC
 EL = 94.80'

SITE BENCHMARK 6
 STA 32+69.45, 15.65' RT
 SET 5/8" REBAR & O.C. CAP
 EL = 96.38'

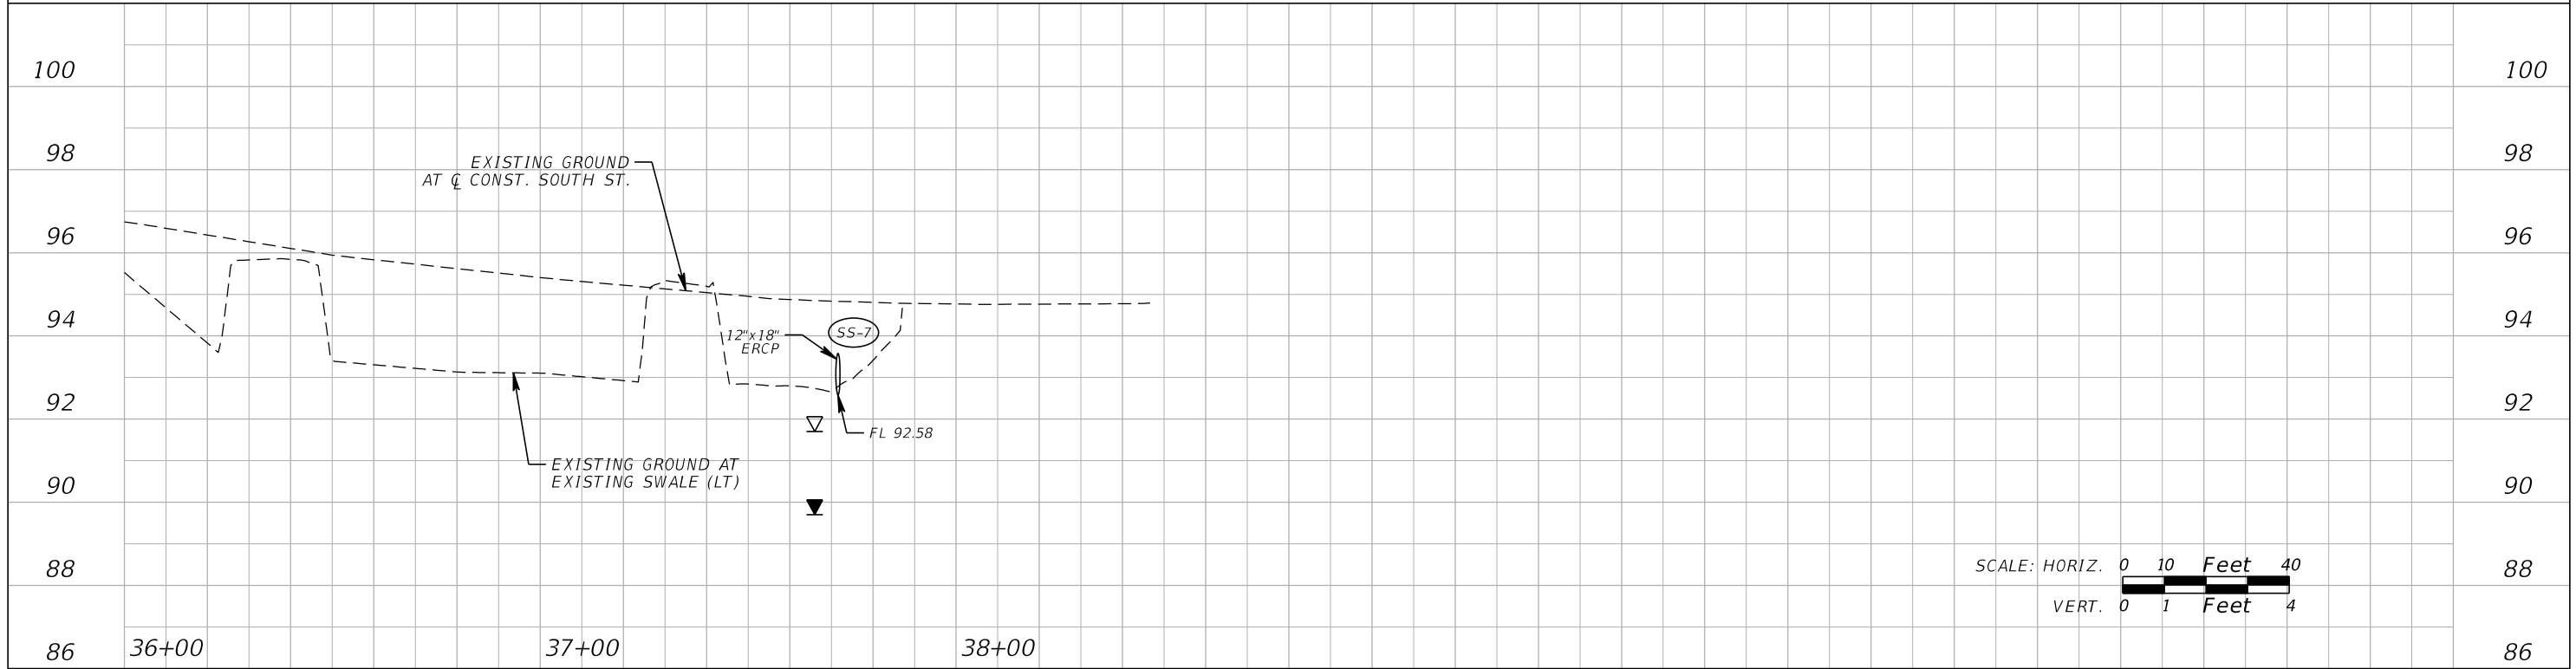

REVISIONS			
DATE	DESCRIPTION	DATE	DESCRIPTION



GTC Engineering Corporation
 98 South Semoran Blvd, Orlando, FL 32807
 Phone Number - 407.380.0402
 Certificate of Authorization Number 6758
 Claude L. Cassagnol, P.E.
 P.E. Number 35490

ORANGE COUNTY PUBLIC WORKS
 GTC PROJECT NO. FLO 23.02
 LITTLE EGYPT SIDEWALK IMPROVEMENTS
 OCPW PROJECT NO. 0193



W. SOUTH ST.
PLAN AND PROFILE
STA. 35+90.00 TO STA. 38+36.63

SHEET NO. 24

FILE: H:\Jobs\FLO23.02-LittleEgypt\roadway\PLPRRD05.dgn
 DATE: 2/16/2018 8:40:30 AM

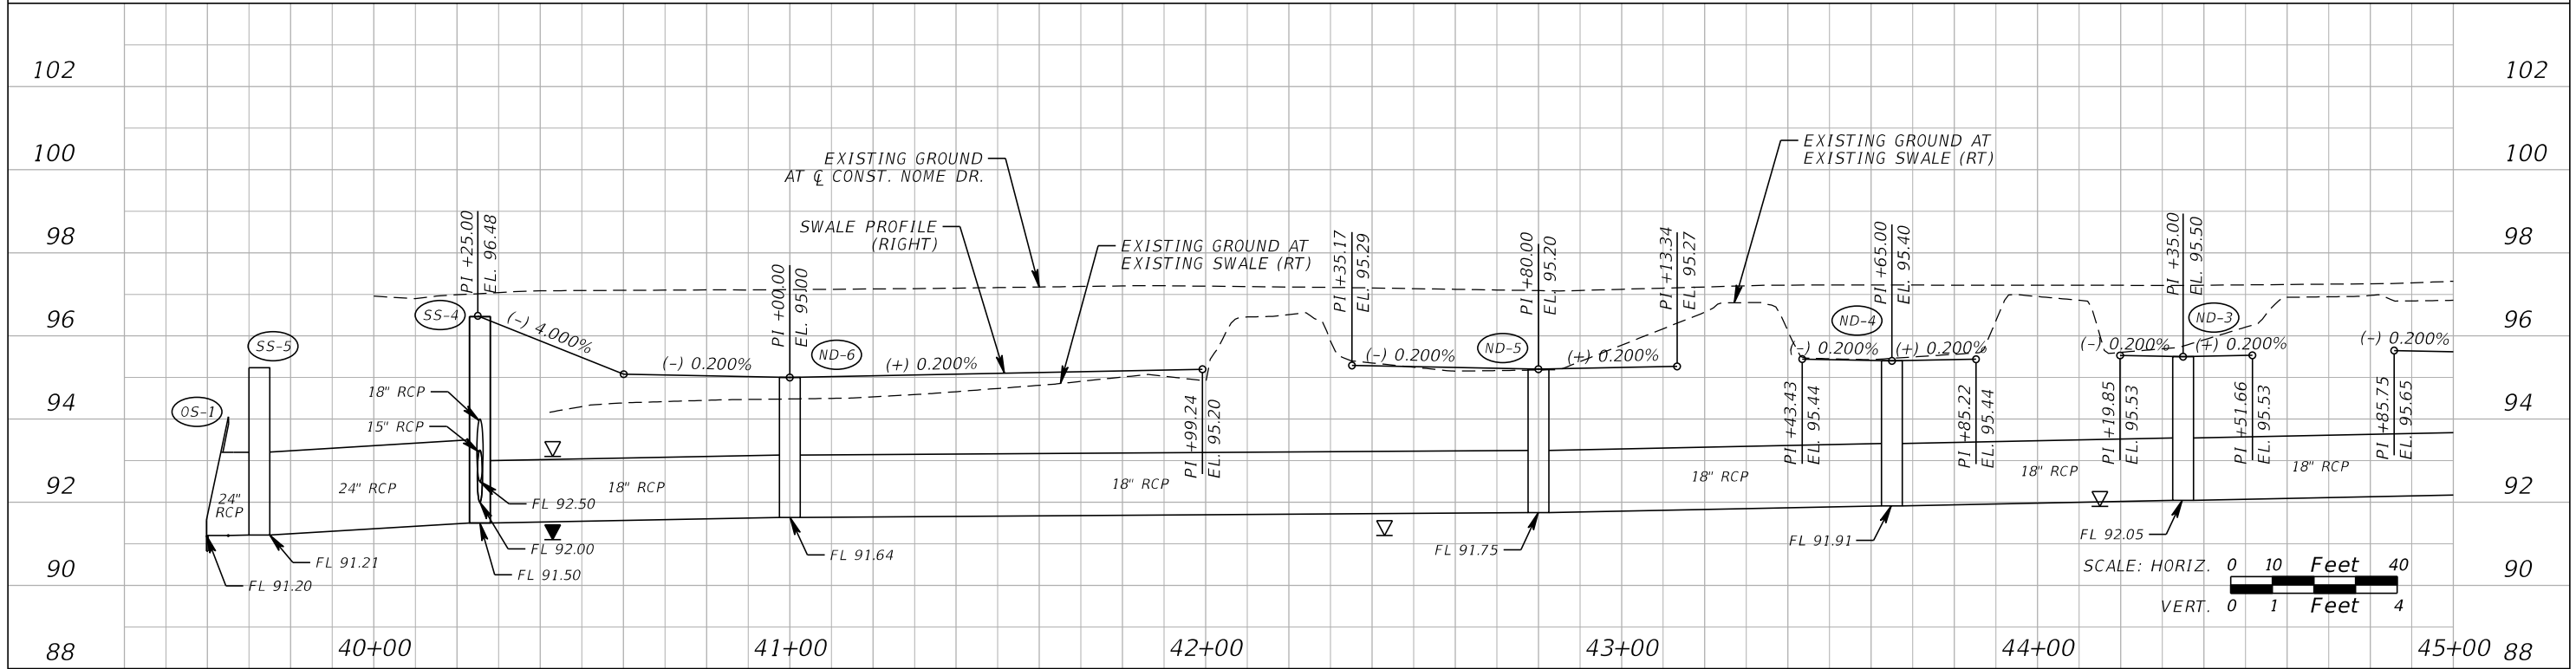
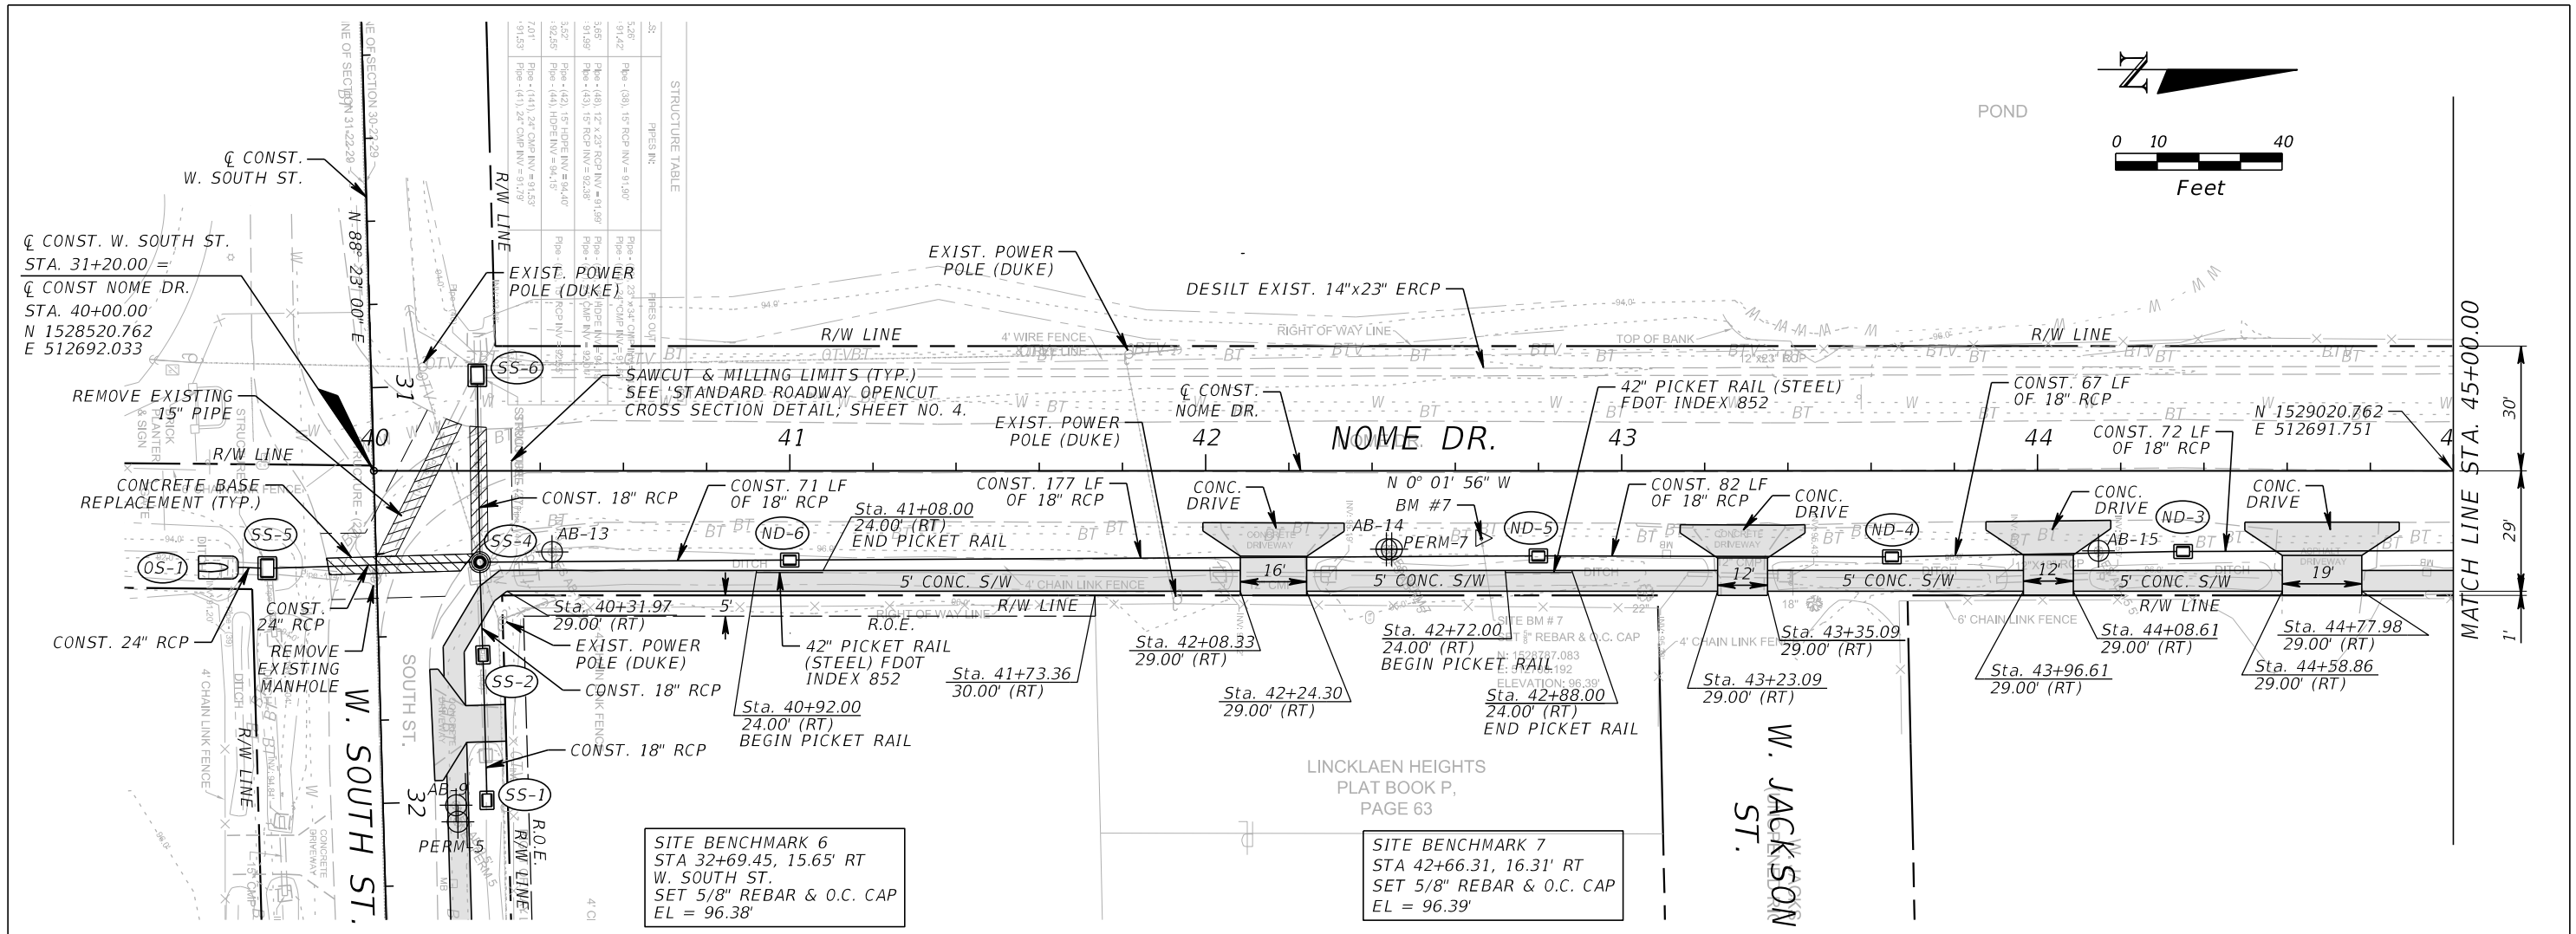


REVISIONS		GTC Engineering Corporation		ORANGE COUNTY PUBLIC WORKS		NOME DR.		SHEET NO.
DATE	DESCRIPTION	DATE	DESCRIPTION	GTC PROJECT NO.	LITTLE EGYPT SIDEWALK IMPROVEMENTS	OCPW PROJECT NO.	PLAN AND PROFILE	
				FLO 23.02		0193	STA. 40+00.00 TO STA. 45+00.00	25

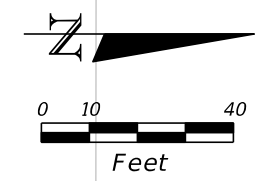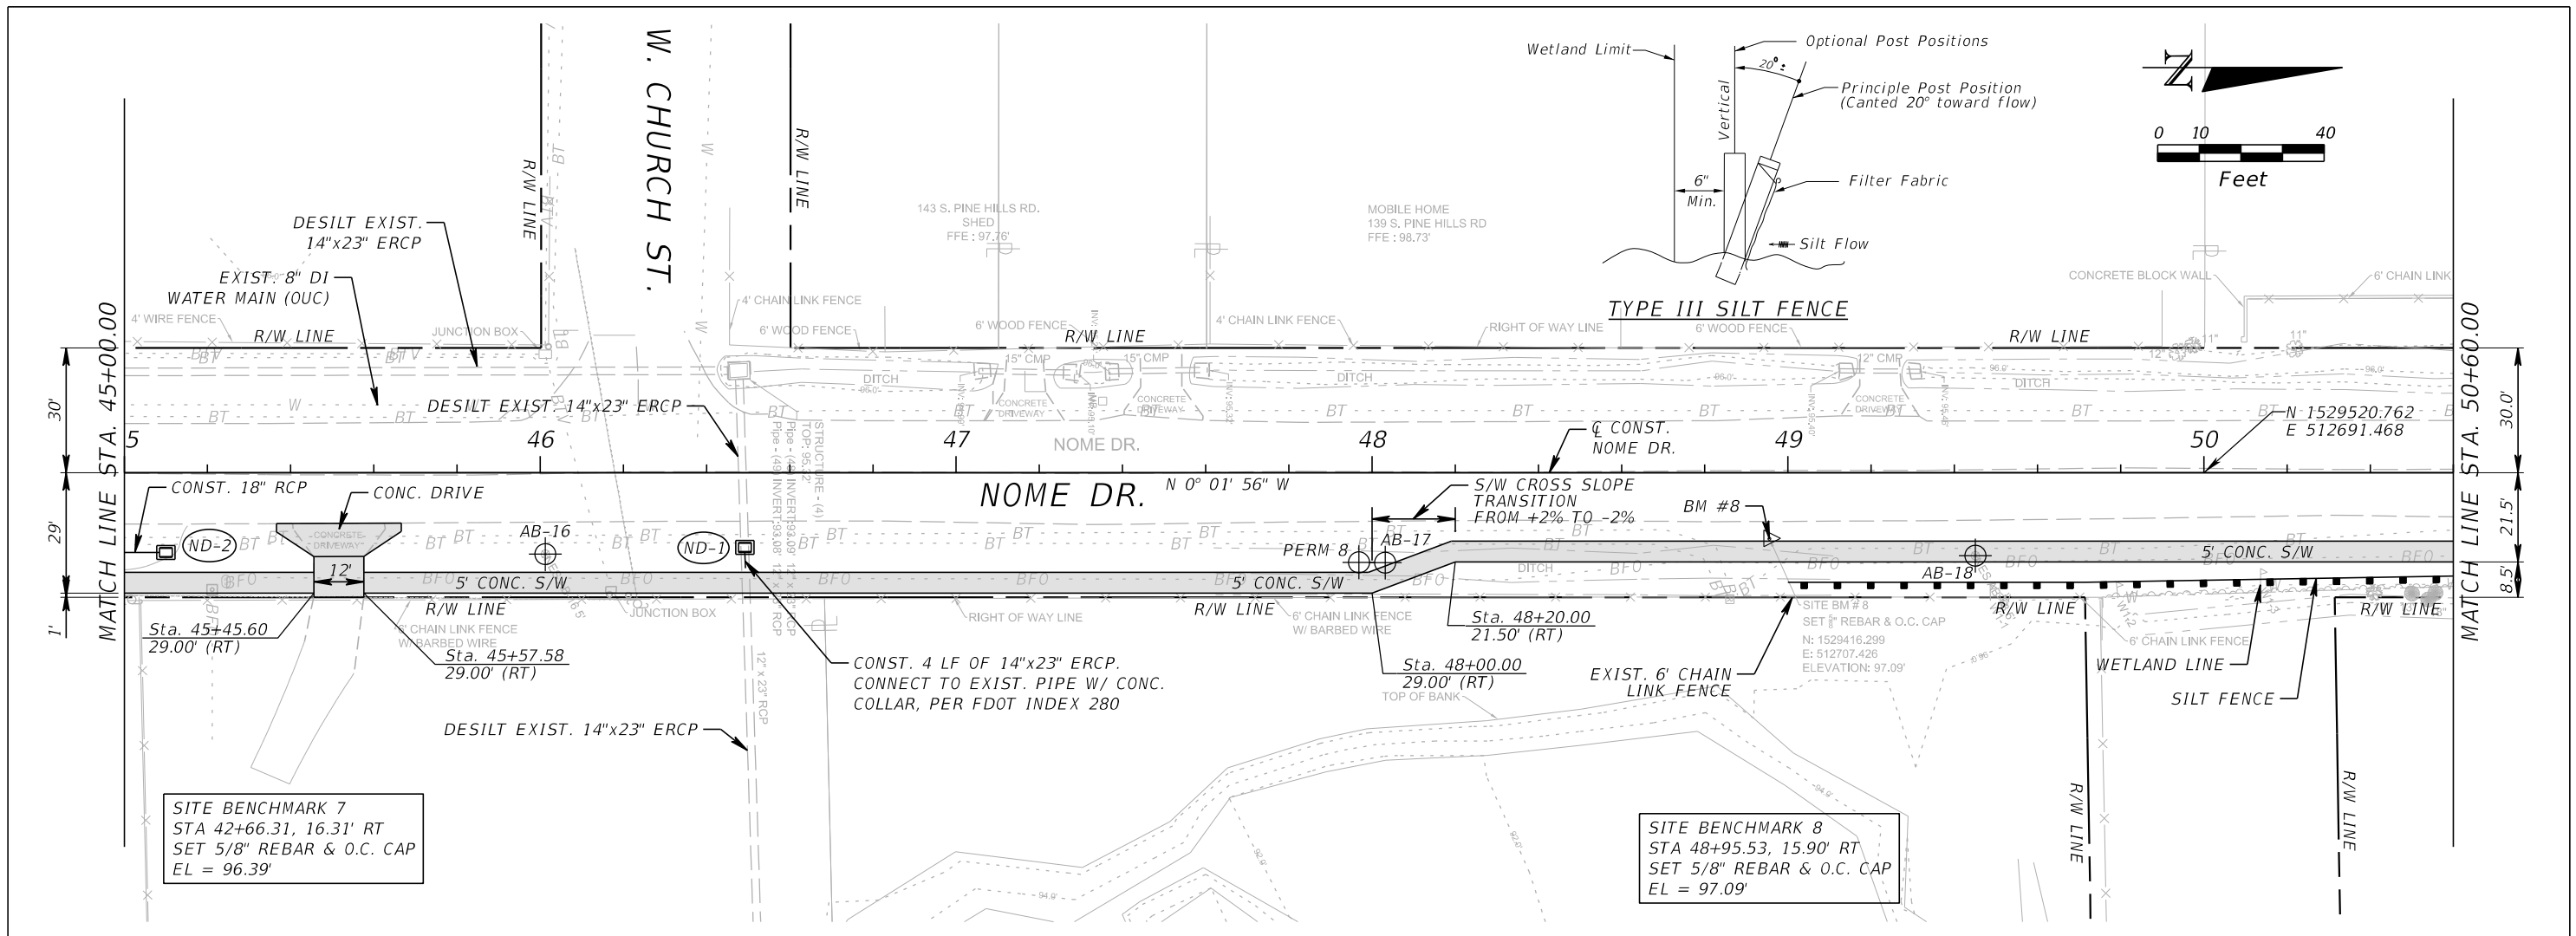

SITE BENCHMARK 8
 STA 48+95.53, 15.90' RT
 SET 5/8" REBAR & O.C. CAP
 EL = 97.09'

 SITE BENCHMARK 7
 STA 42+66.31, 16.31' RT
 SET 5/8" REBAR & O.C. CAP
 EL = 96.39'

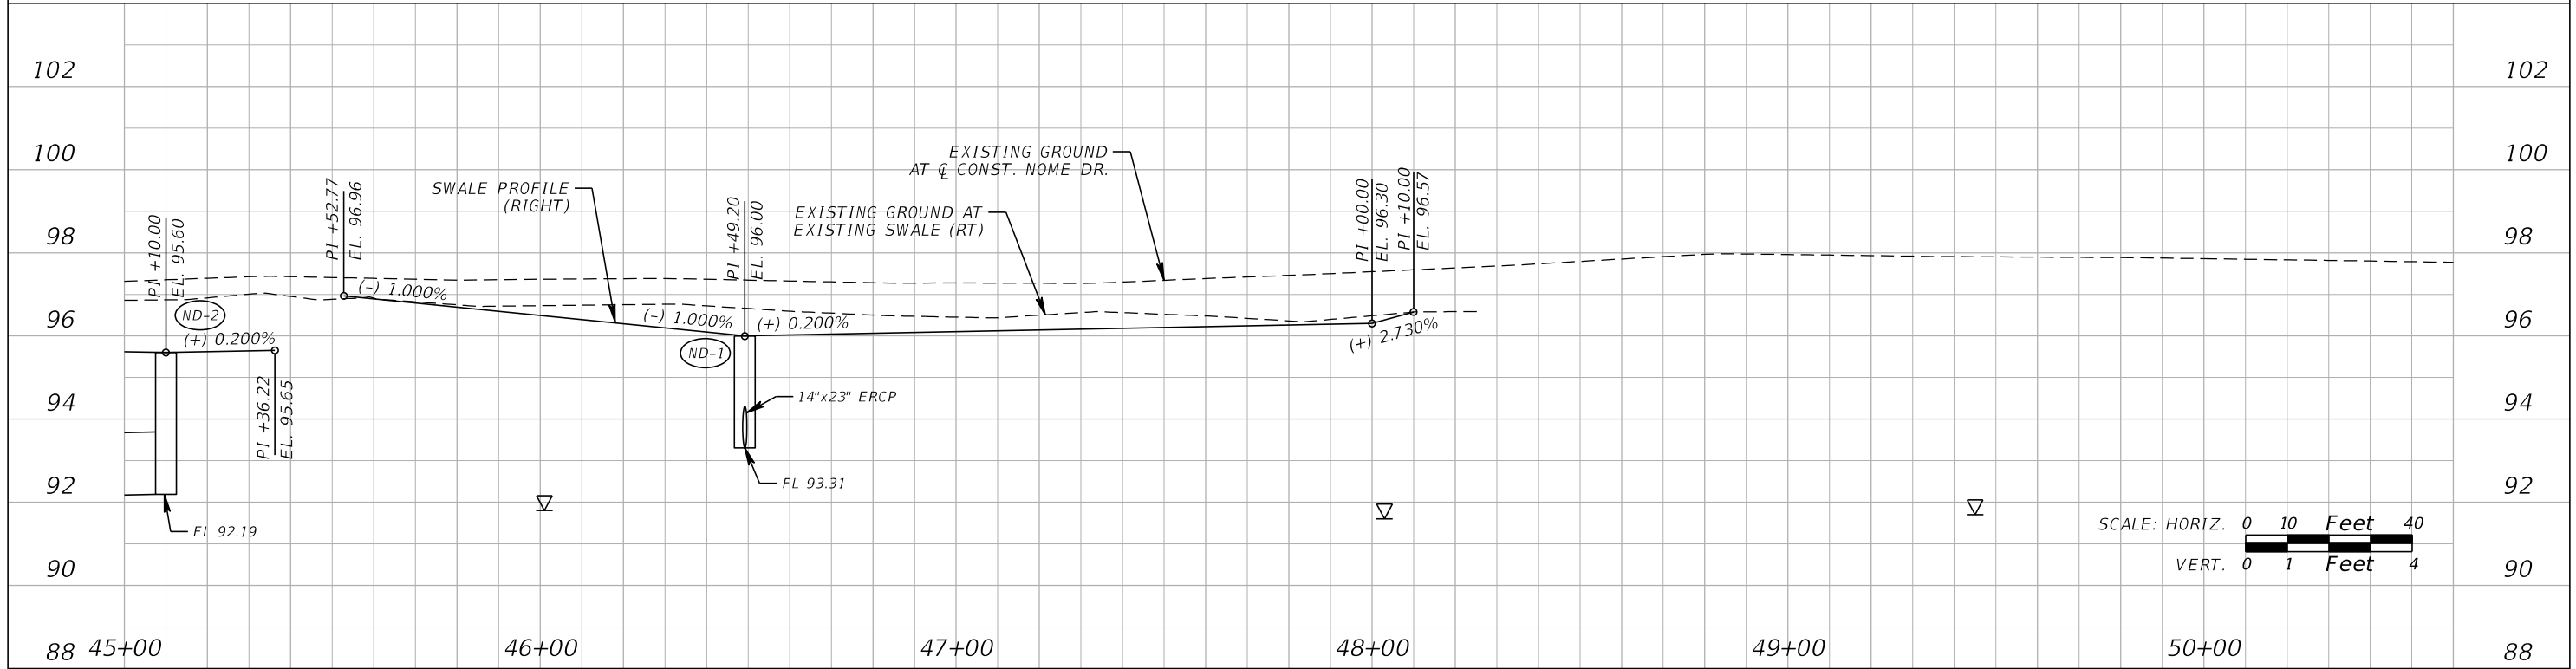

REVISIONS			
DATE	DESCRIPTION	DATE	DESCRIPTION

GTC Engineering Corporation
 98 South Semoran Blvd, Orlando, FL 32807
 Phone Number - 407.380.0402



ORANGE COUNTY PUBLIC WORKS

GTC PROJECT NO. FLO 23.02	LITTLE EGYPT SIDEWALK IMPROVEMENTS	OCPW PROJECT NO. 0193
------------------------------	--	--------------------------

NOME DR.
PLAN AND PROFILE
STA. 45+00.00 TO STA. 50+60.00



SHEET NO.
26

FILE: H:\Jobs\FLO23.02-LittleEgypt\roadway\PLPRD07.dgn
 DATE: 4/17/2018 2:26:42 PM

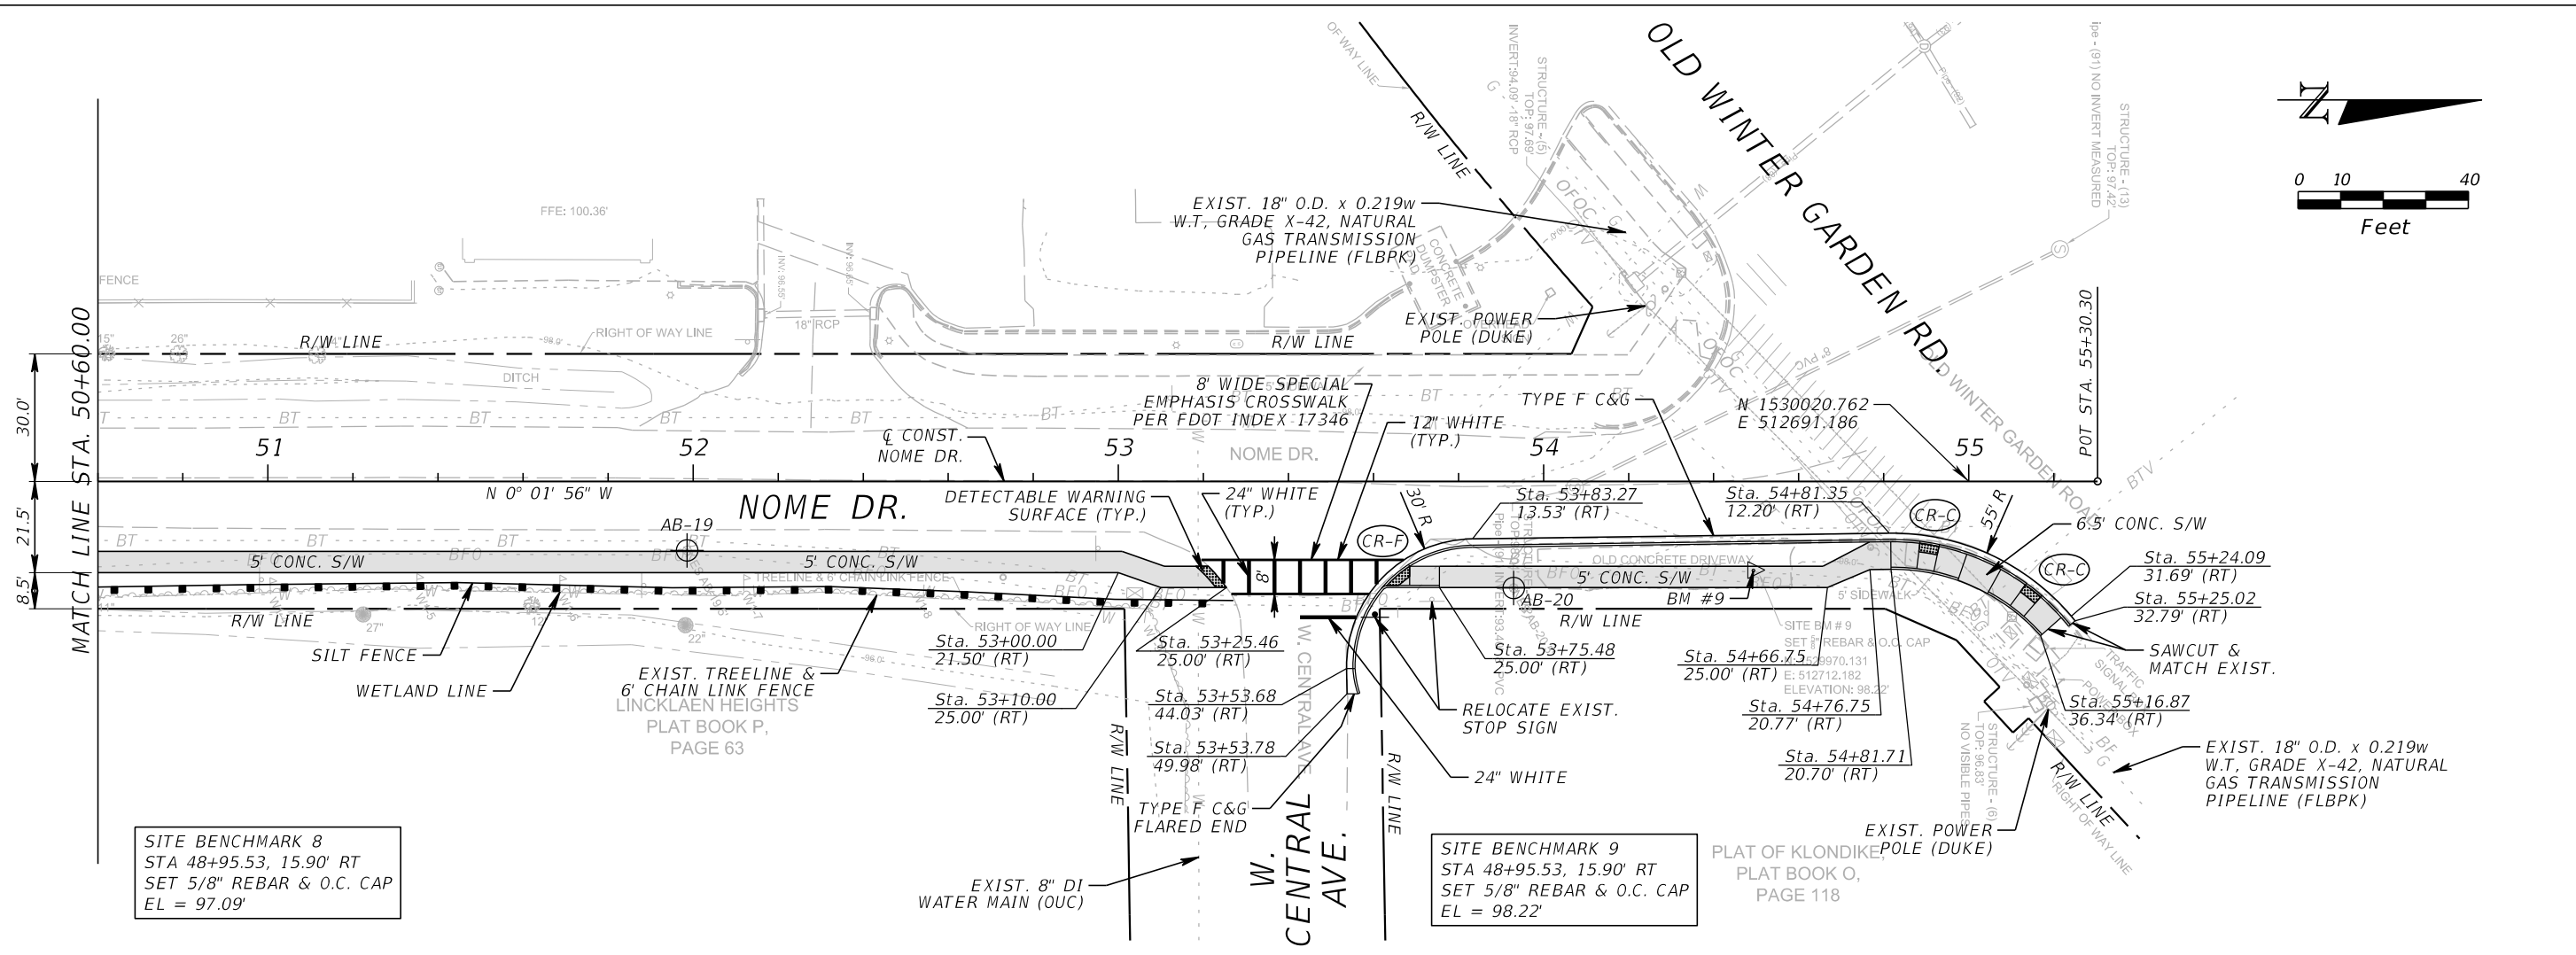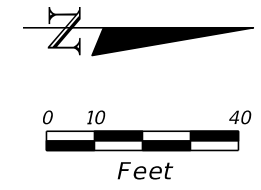



SITE BENCHMARK 8
 STA 48+95.53, 15.90' RT
 SET 5/8" REBAR & O.C. CAP
 EL = 97.09'

 SITE BENCHMARK 9
 STA 48+95.53, 15.90' RT
 SET 5/8" REBAR & O.C. CAP
 EL = 98.22'

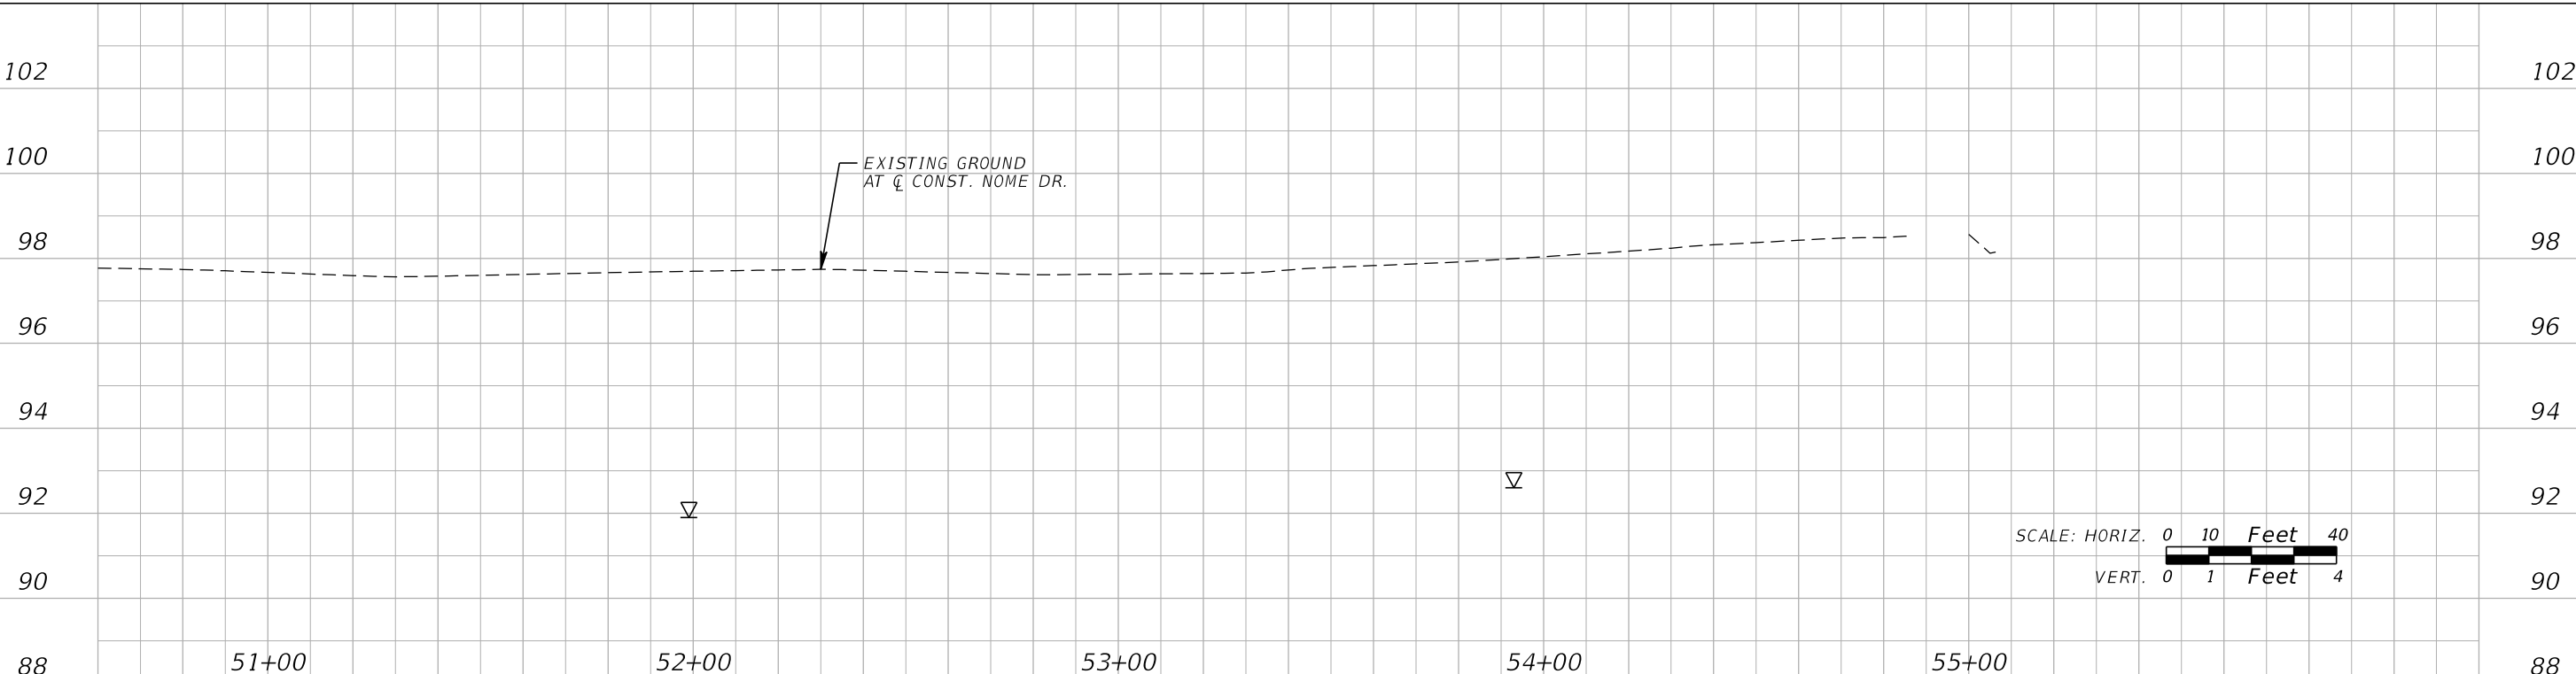

REVISIONS				GTC Engineering Corporation		ORANGE COUNTY PUBLIC WORKS		NOME DR.		SHEET NO.
DATE	DESCRIPTION	DATE	DESCRIPTION	98 South Semoran Blvd, Orlando, FL 32807 Phone Number - 407.380.0402		GTC PROJECT NO.	LITTLE EGYPT SIDEWALK IMPROVEMENTS	OCPW PROJECT NO.	PLAN AND PROFILE	
				Certificate of Authorization Number 6758		FLO 23.02		0193	STA. 50+60.00 TO STA. 55+30.30	27


 
FILE: H:\Jobs\F1023.02-LittleEgypt\roadway\PLPRRD08.dgn
 DATE: 4/17/2018 2:26:14 PM

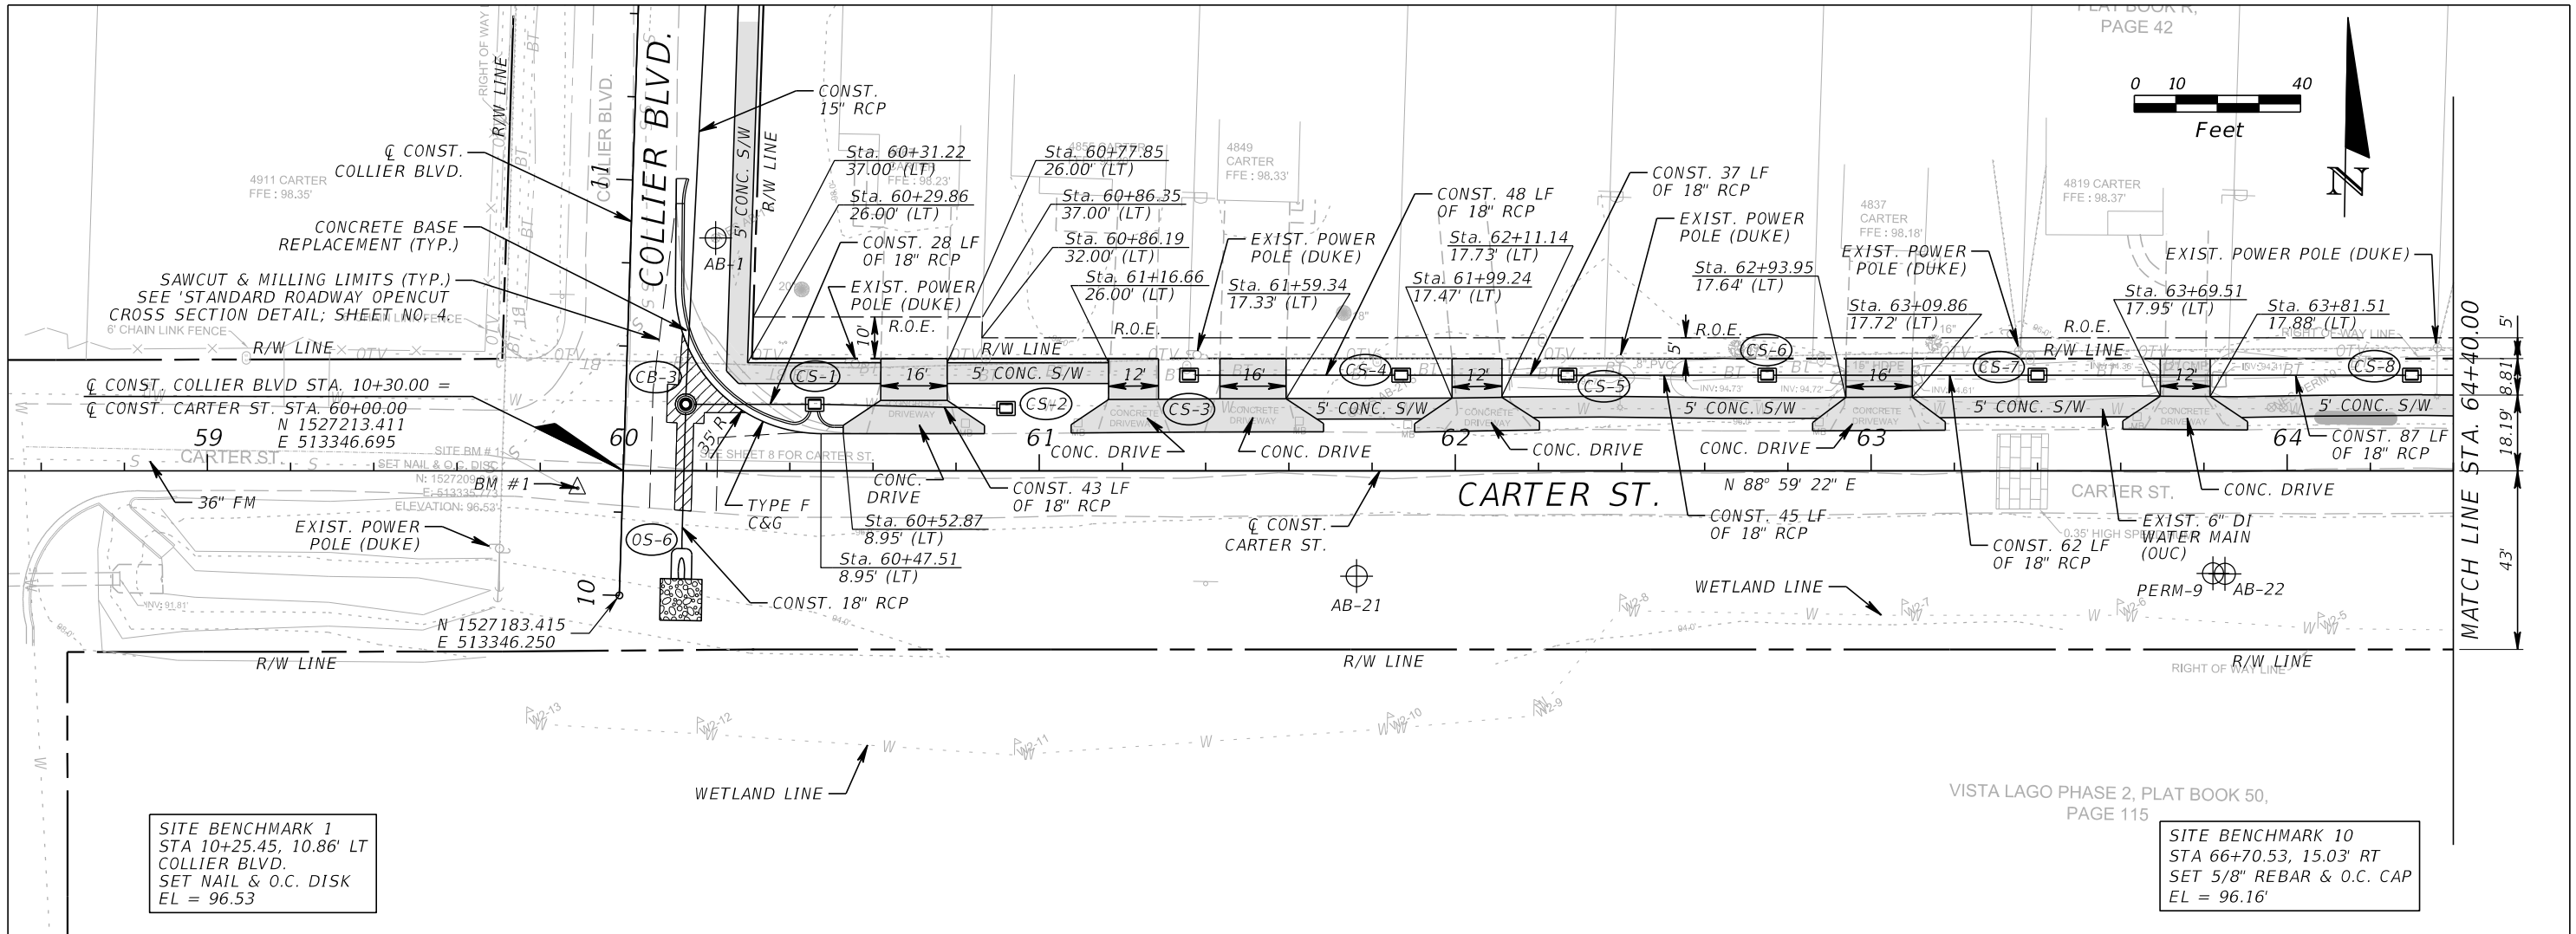

SITE BENCHMARK 1
STA 10+25.45, 10.86' LT
COLLIER BLVD.
SET NAIL & O.C. DISK
EL = 96.53

SITE BENCHMARK 10
STA 66+70.53, 15.03' RT
SET 5/8" REBAR & O.C. CAP
EL = 96.16'

 

VISTA LAGO PHASE 2, PLAT BOOK 50,
PAGE 115

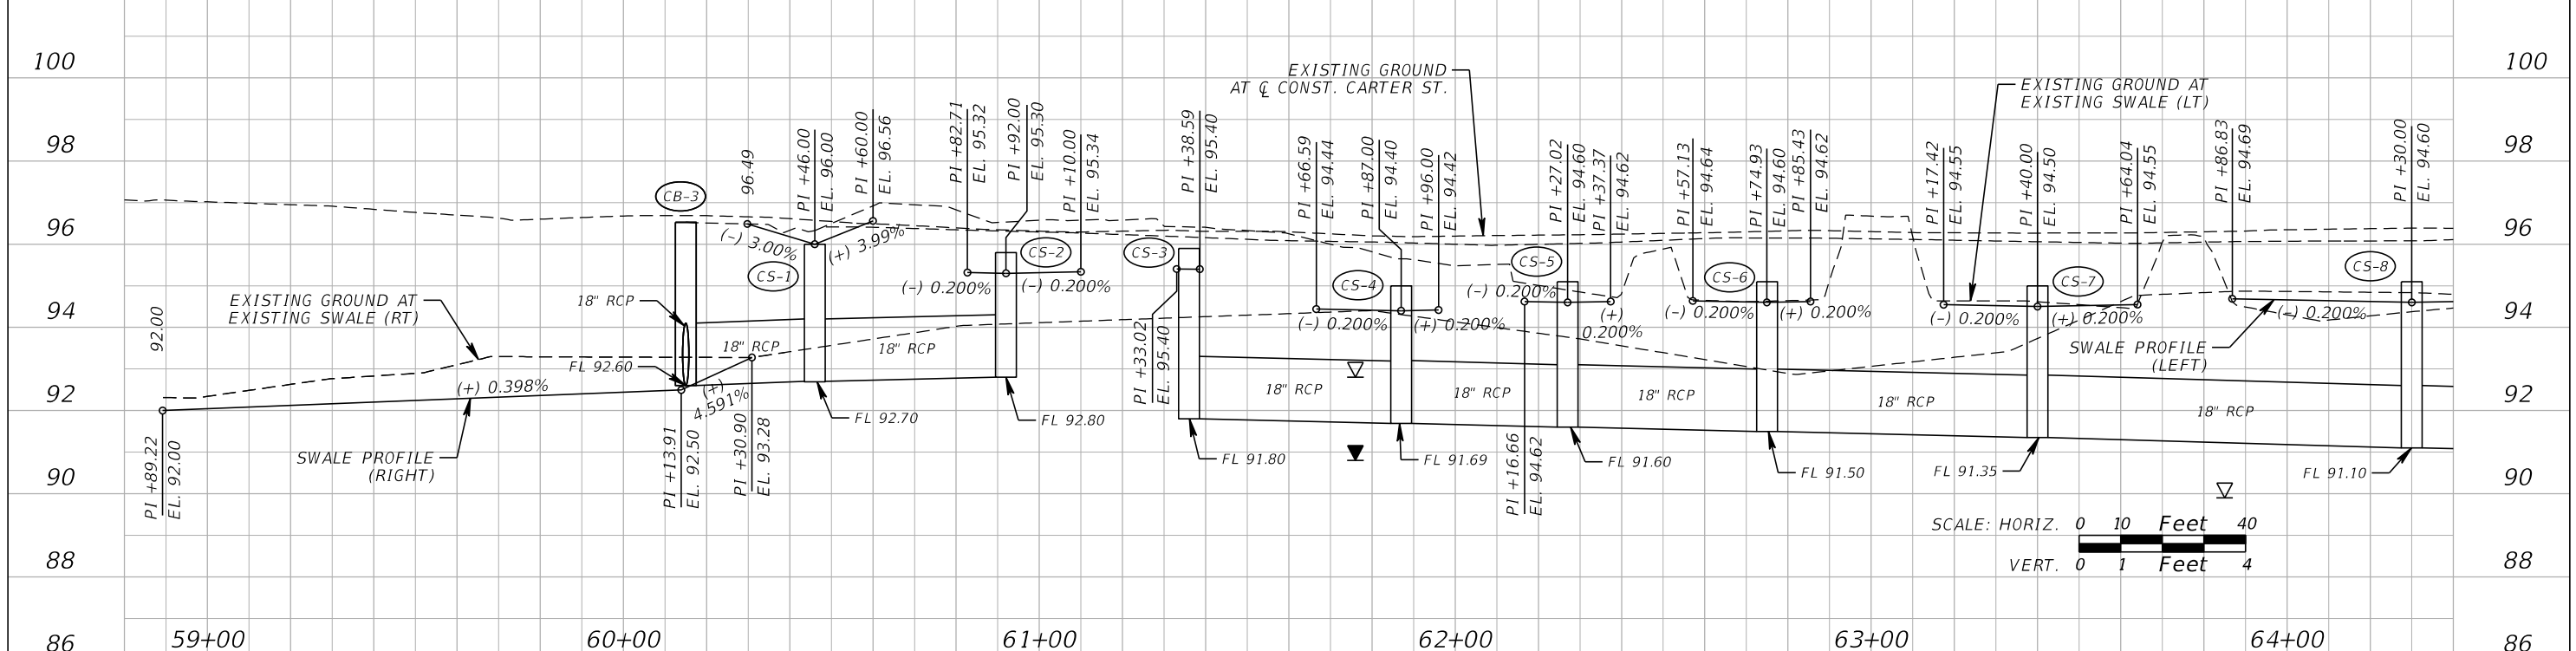

REVISIONS			
DATE	DESCRIPTION	DATE	DESCRIPTION



GTC Engineering Corporation 98 South Semoran Blvd, Orlando, FL 32807 Phone Number - 407.380.0402 Certificate of Authorization Number 6758 Claude L. Cassagnol, P.E. P.E. Number 35490		ORANGE COUNTY PUBLIC WORKS GTC PROJECT NO. FLO 23.02 LITTLE EGYPT SIDEWALK IMPROVEMENTS OCPW PROJECT NO. 0193	
---	--	---	--

CARTER ST. PLAN AND PROFILE STA. 58+89.00 TO STA. 64+40.00		SHEET NO. 28
---	--	-----------------

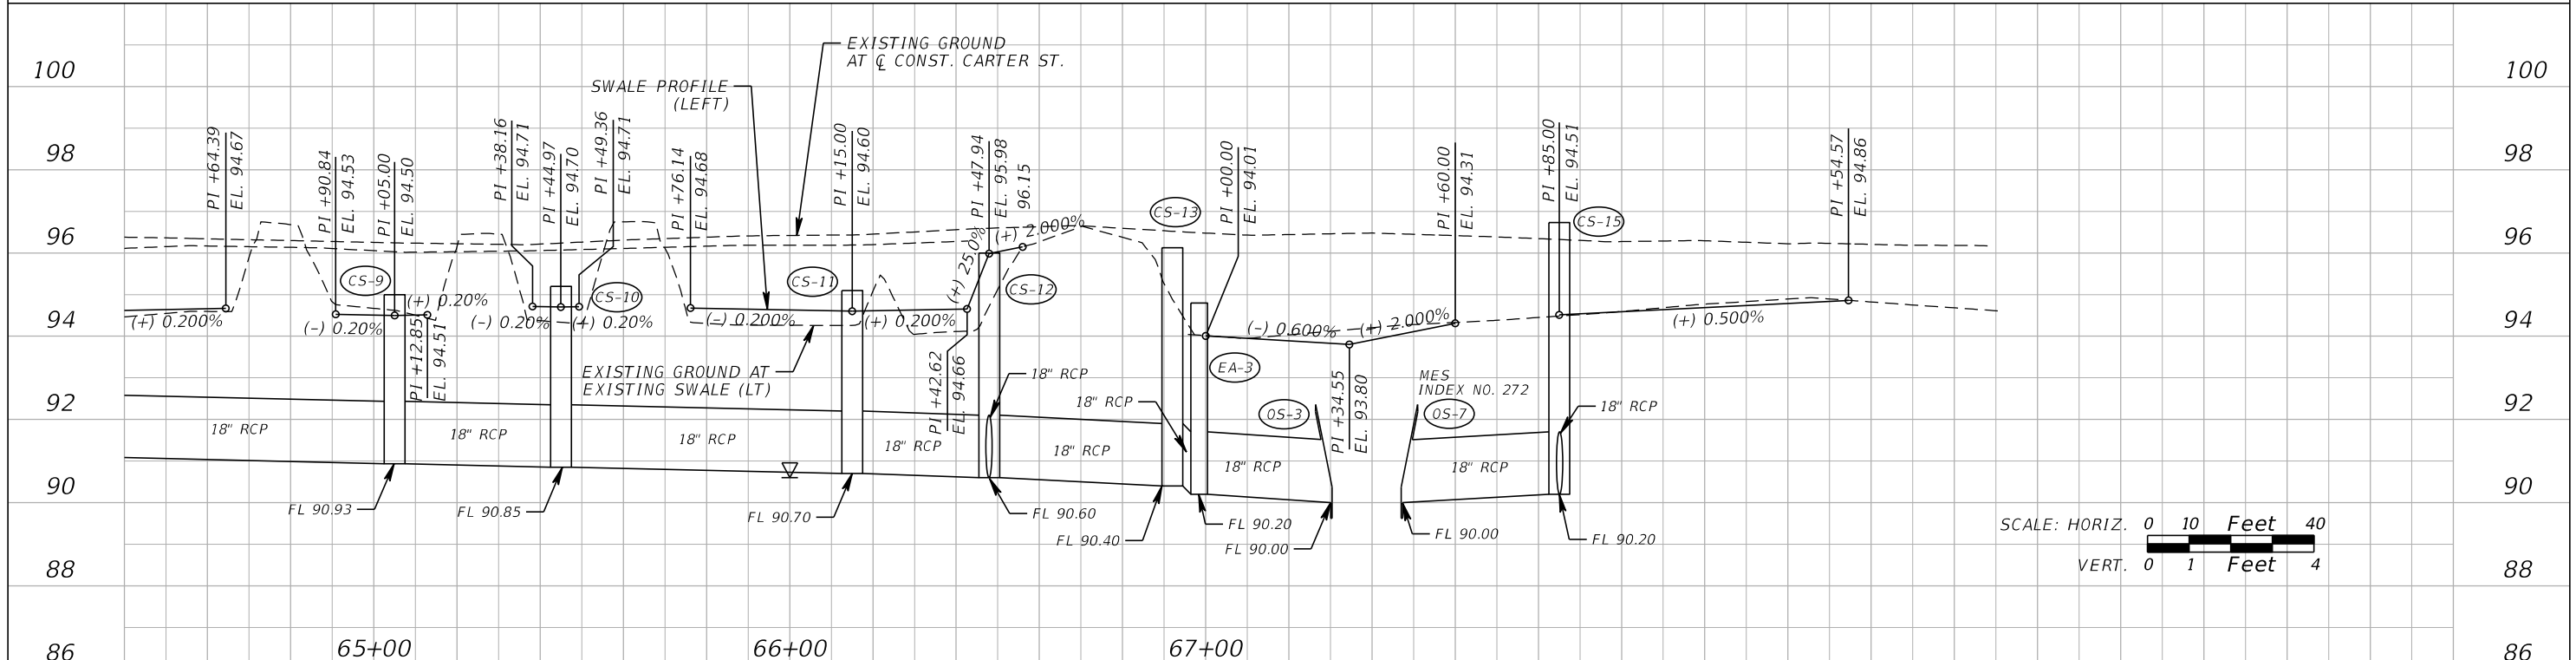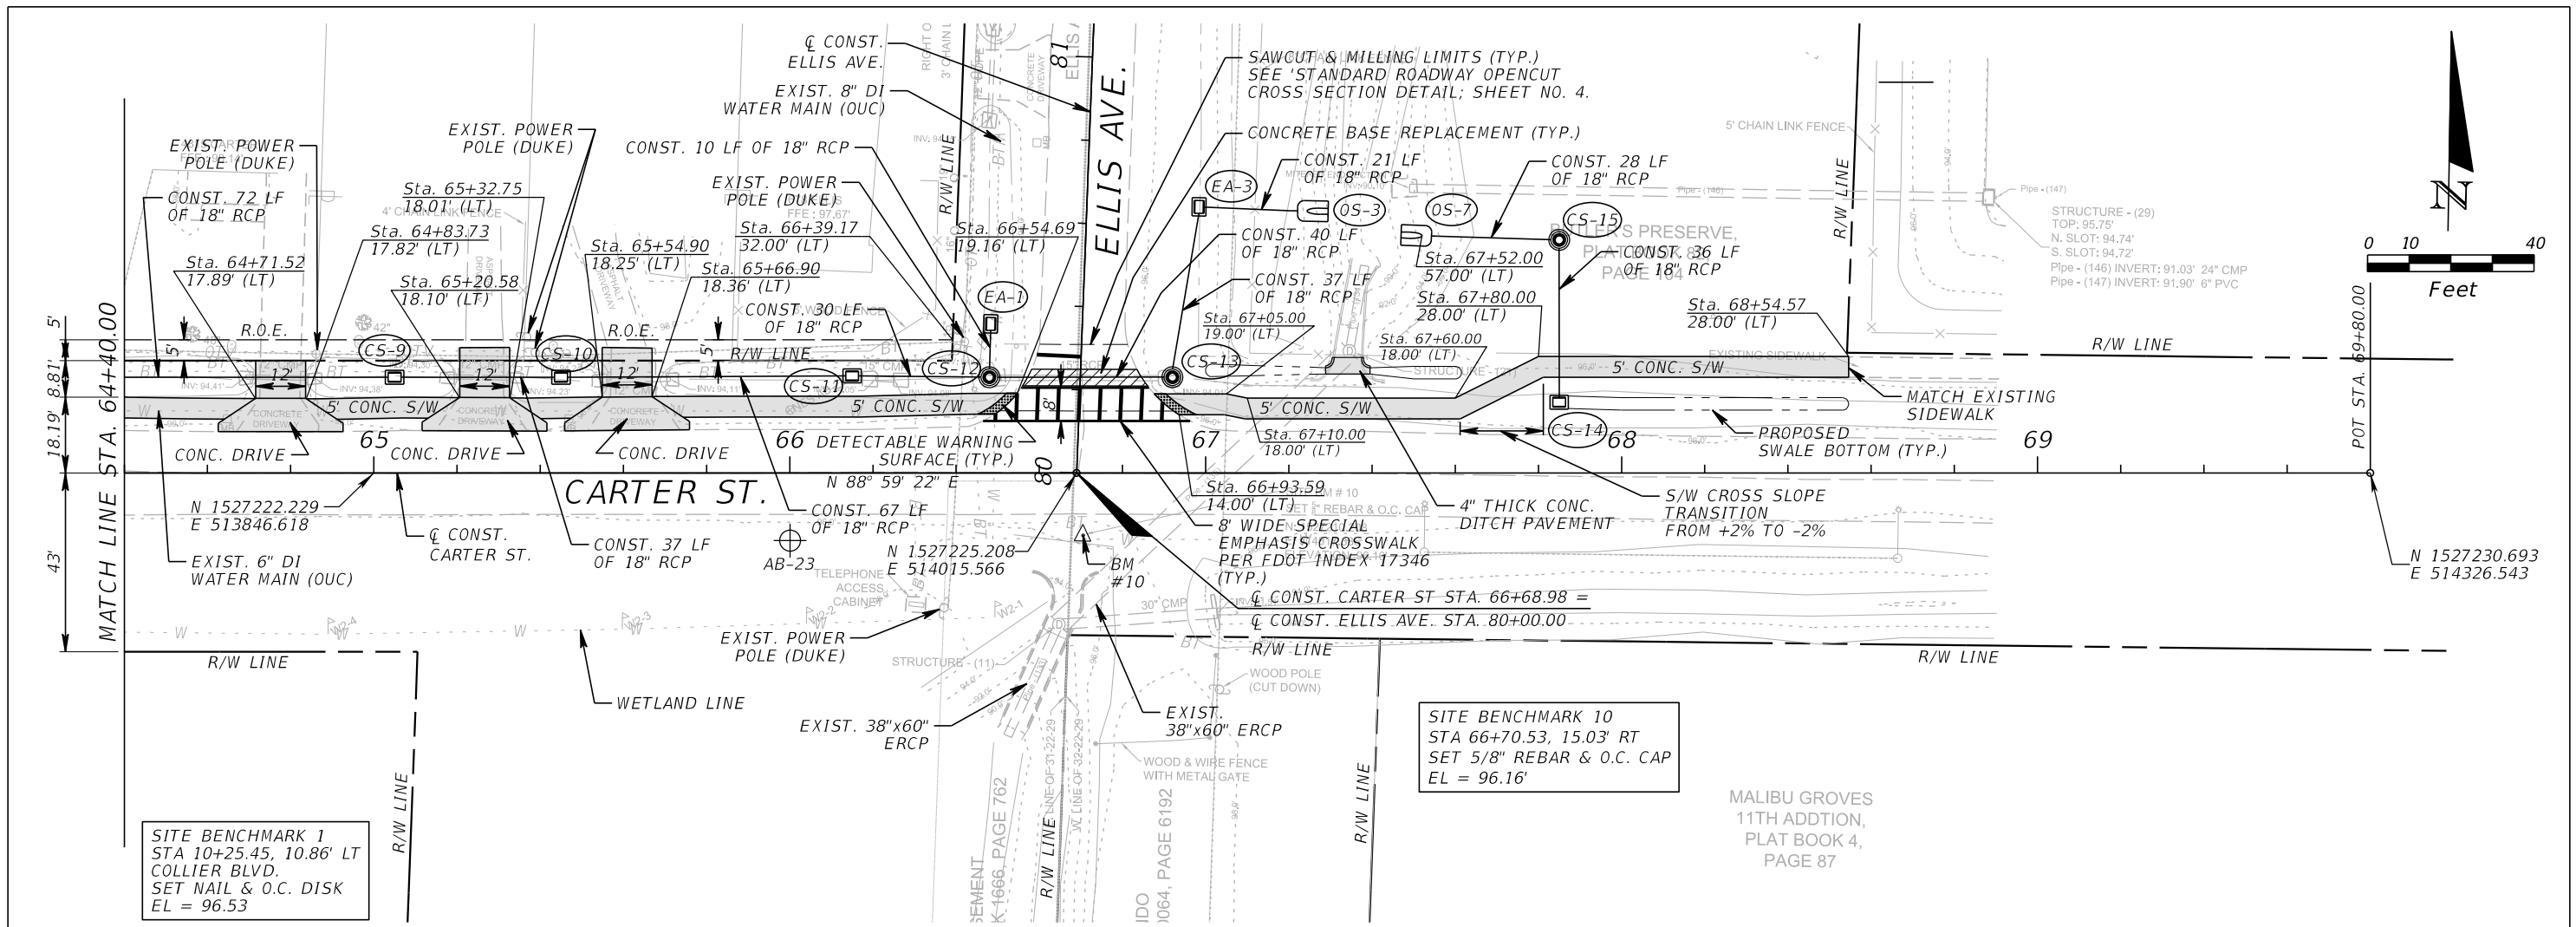

REVISIONS				GTC Engineering Corporation 98 South Semoran Blvd, Orlando, FL 32807 Phone Number - 407.380.0402 Certificate of Authorization Number 6758	ORANGE COUNTY PUBLIC WORKS		CARTER ST. PLAN AND PROFILE STA. 64+40.00 TO STA. 67+54.57	SHEET NO. 29
DATE	DESCRIPTION	DATE	DESCRIPTION		GTC PROJECT NO. FLO 23.02	OCPW PROJECT NO. 0193		
				Claude L. Cassagnol, P.E. P.E. Number 35490 <td>LITTLE EGYPT SIDEWALK IMPROVEMENTS</td> <td> </td> <td> </td>	LITTLE EGYPT SIDEWALK IMPROVEMENTS			

FILE: H:\Jobs\FLO23.02-LittleEgypt\roadway\PLPRRD10.dgn
 DATE: 3/7/2018 9:46:27 AM

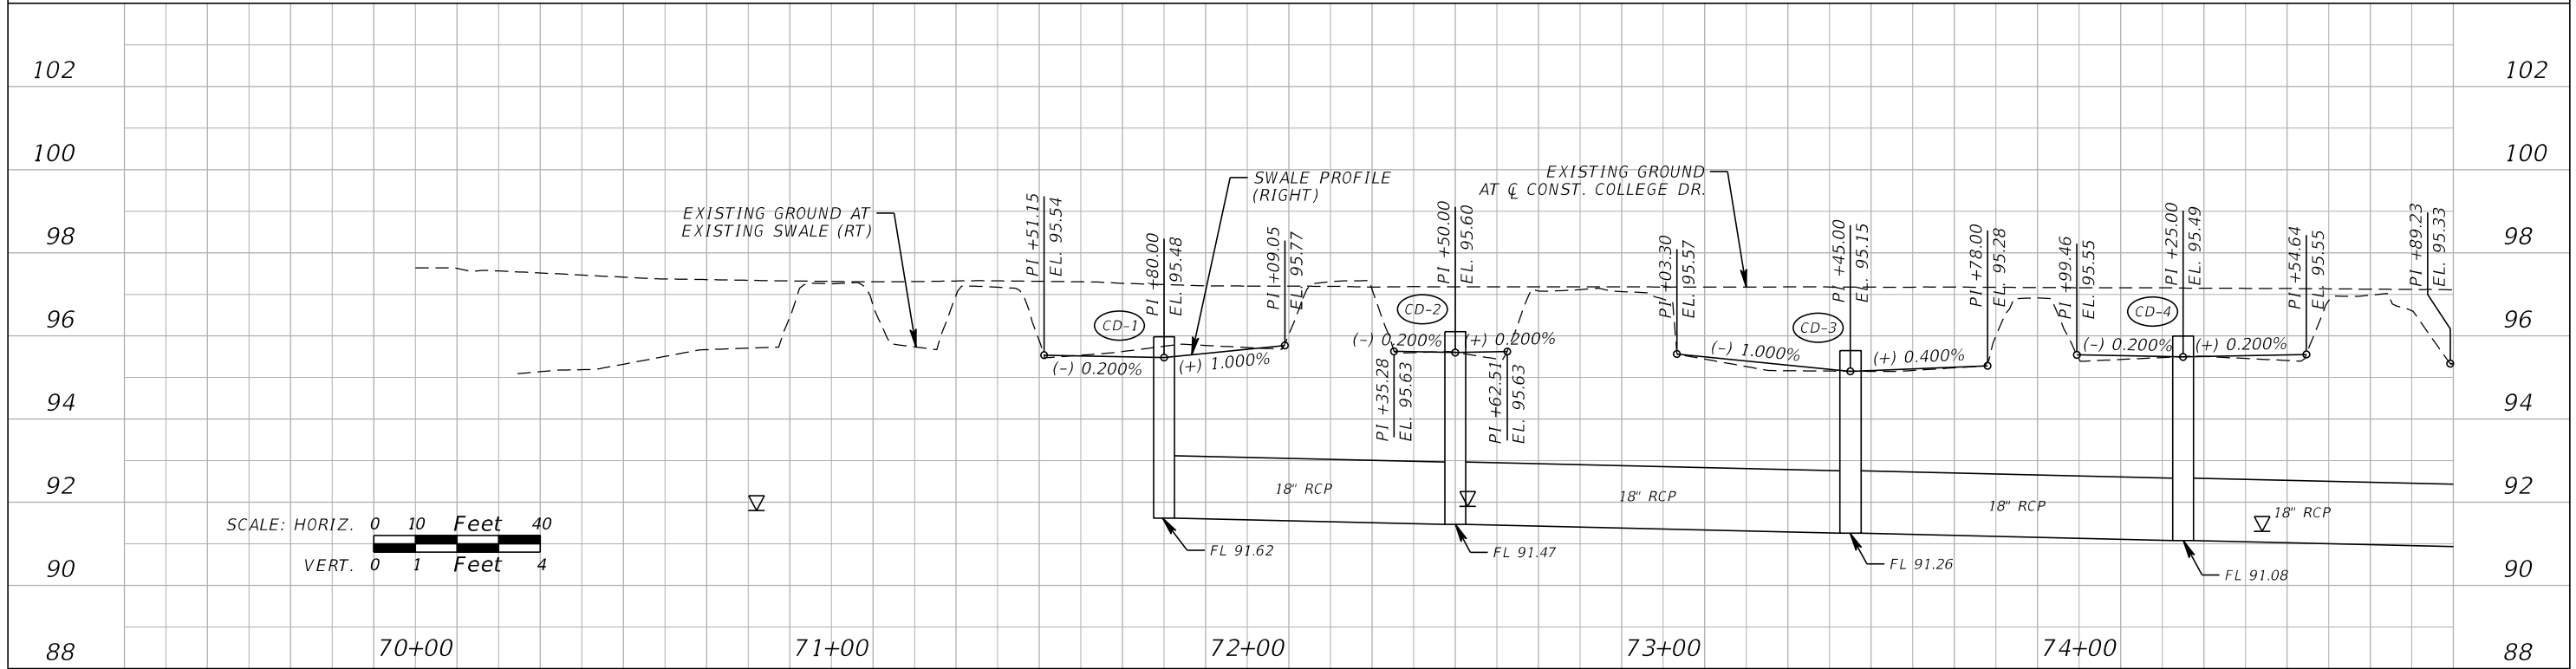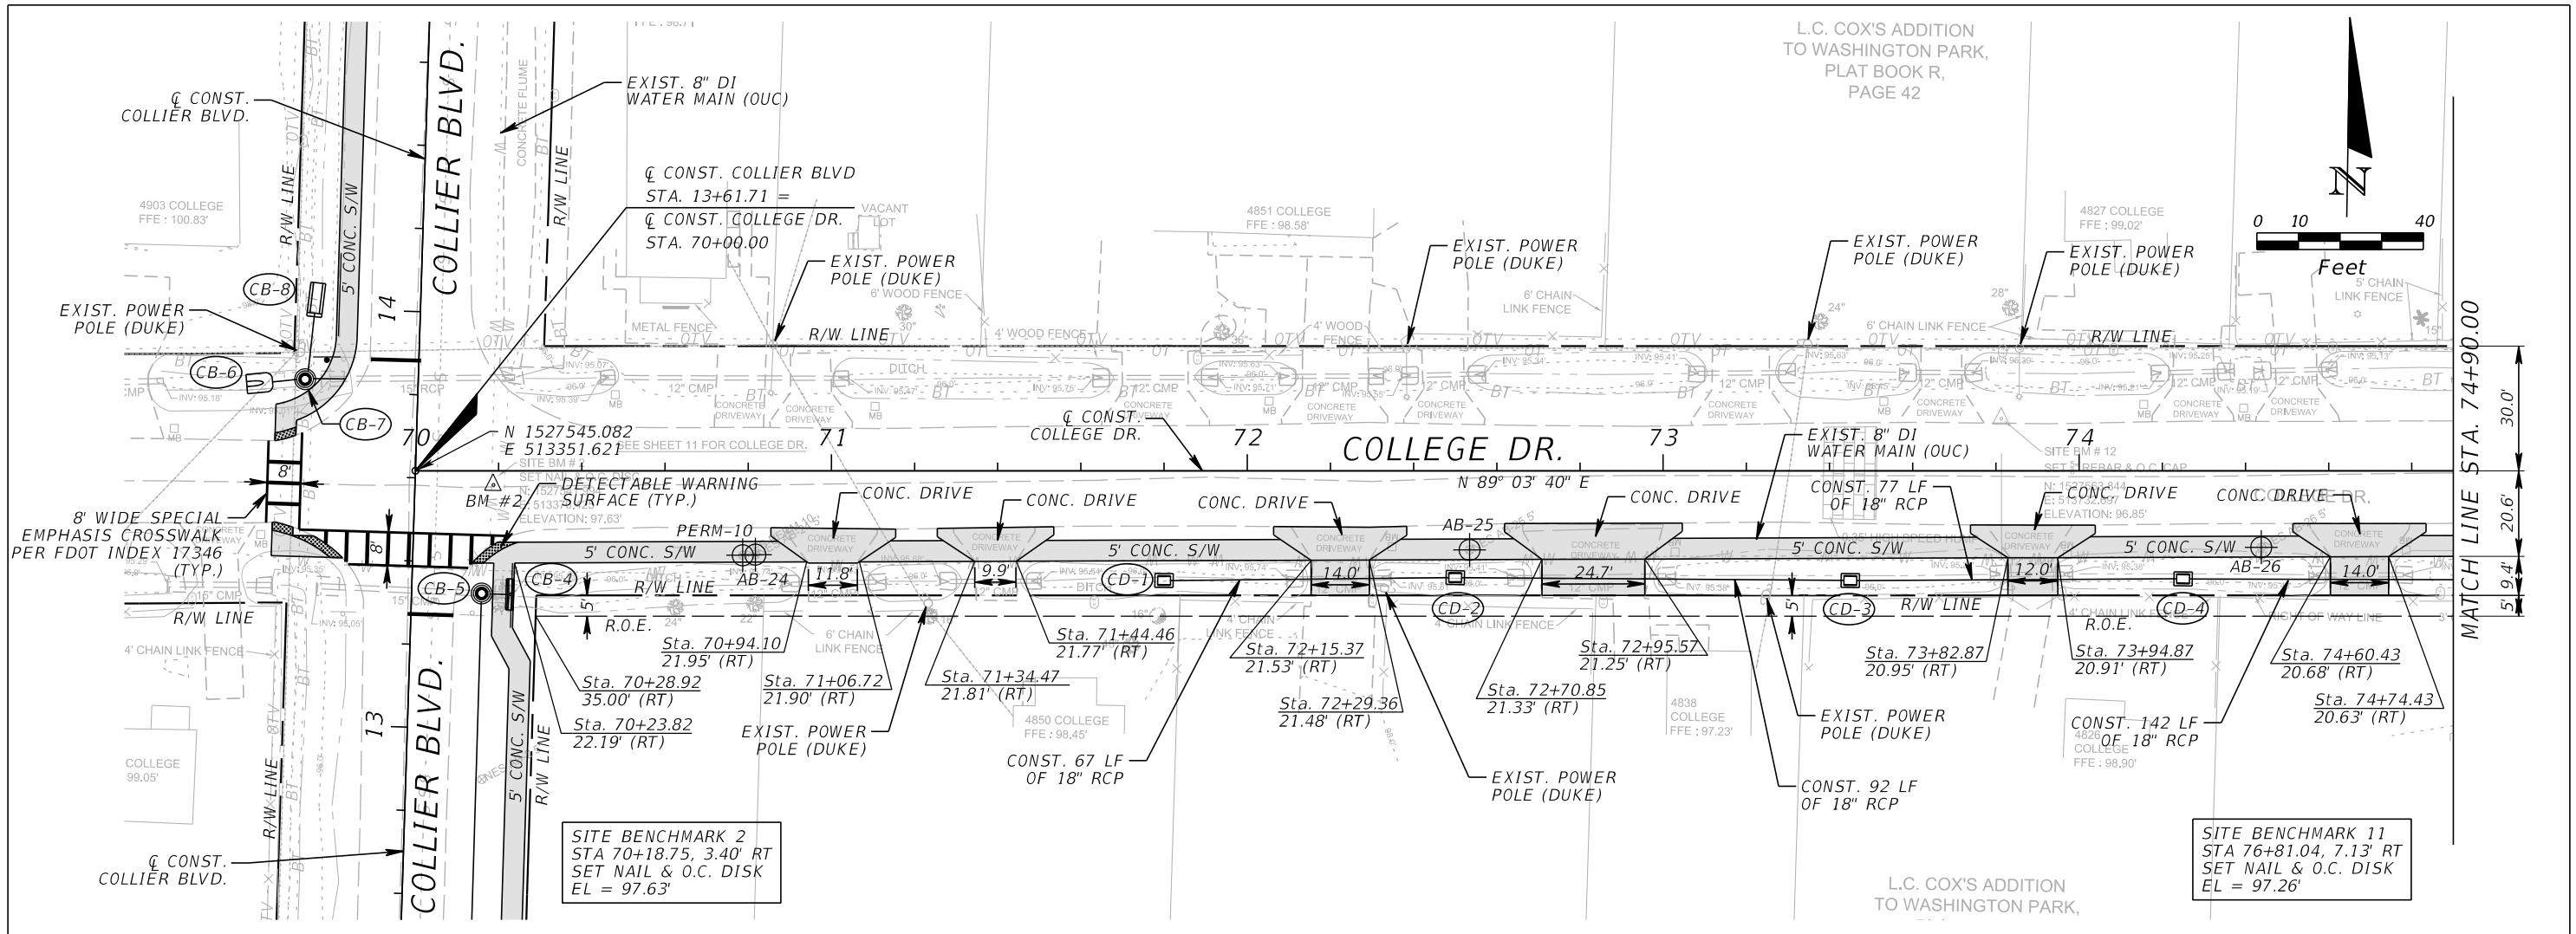

REVISIONS			
DATE	DESCRIPTION	DATE	DESCRIPTION




GTC Engineering Corporation
 98 South Semoran Blvd, Orlando, FL 32807
 Phone Number - 407.380.0402
 Certificate of Authorization Number 6758
 Claude L. Cassagnol, P.E.
 P.E. Number 35490

ORANGE COUNTY PUBLIC WORKS
 GTC PROJECT NO. FLO 23.02
 LITTLE EGYPT SIDEWALK IMPROVEMENTS
 OCPW PROJECT NO. 0193

COLLEGE DR.
PLAN AND PROFILE
STA. 70+00.00 TO STA. 74+90.00

SHEET NO. 30

FILE: H:\Jobs\FLO23.02-LittleEgypt\roadway\PLPRDII.dgn
 DATE: 2/16/2018 8:40:39 AM

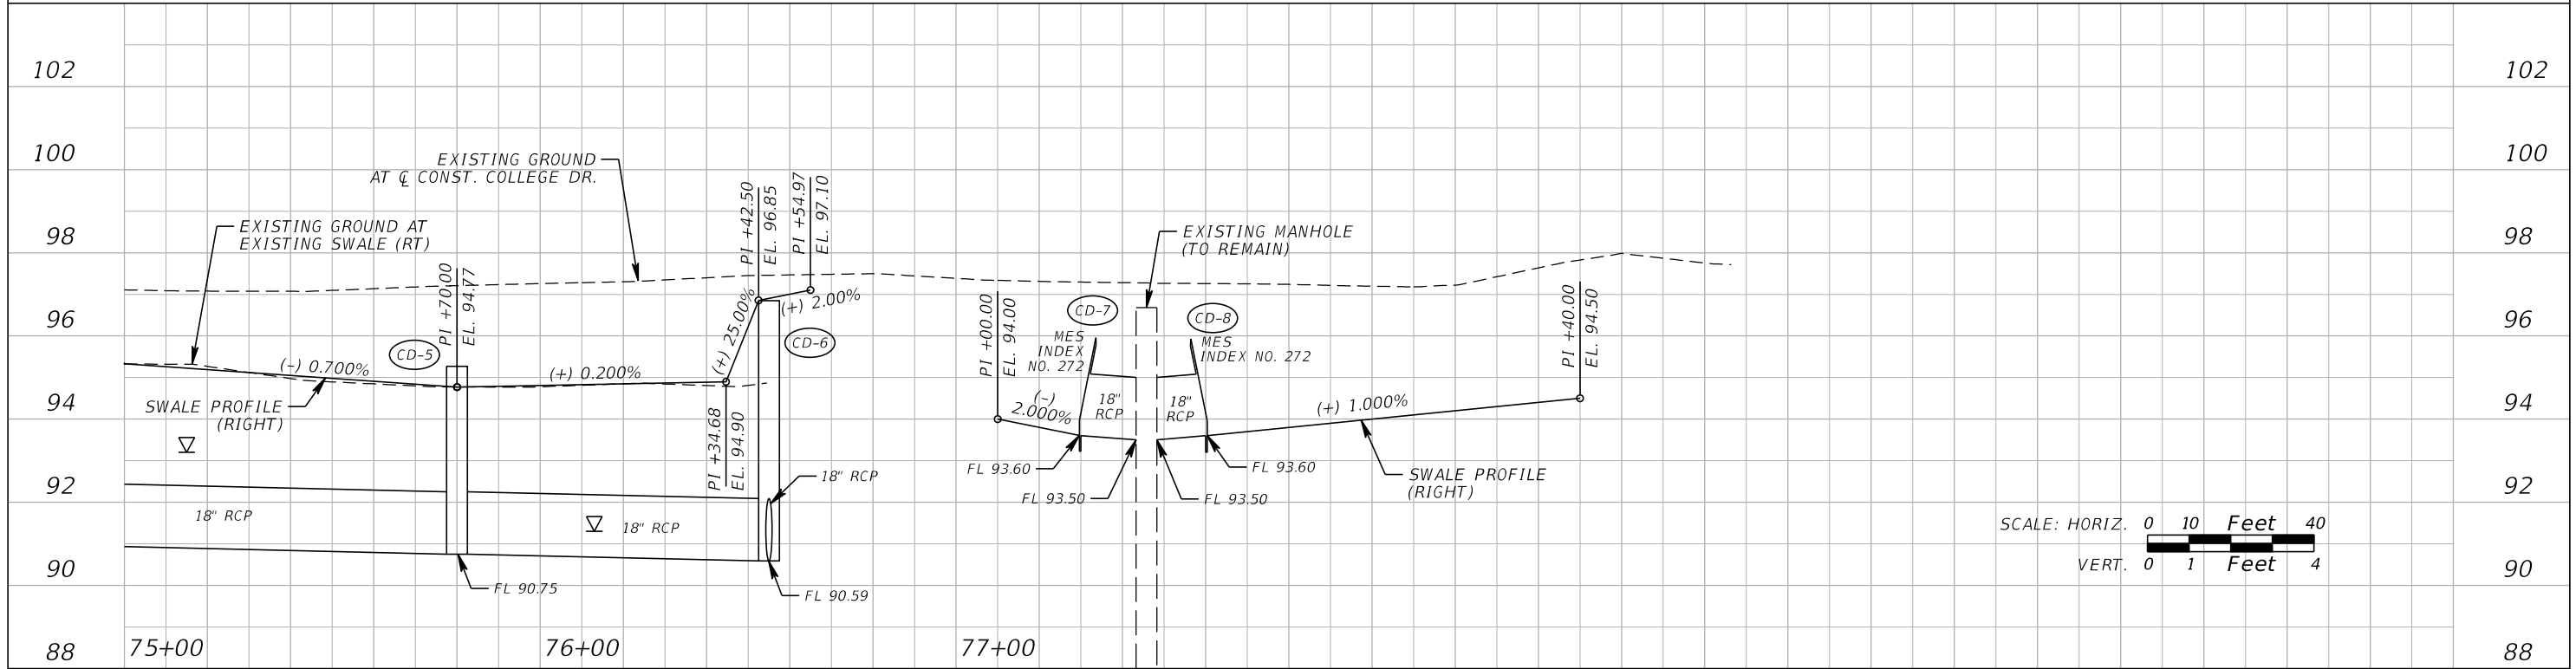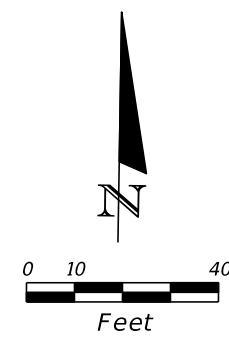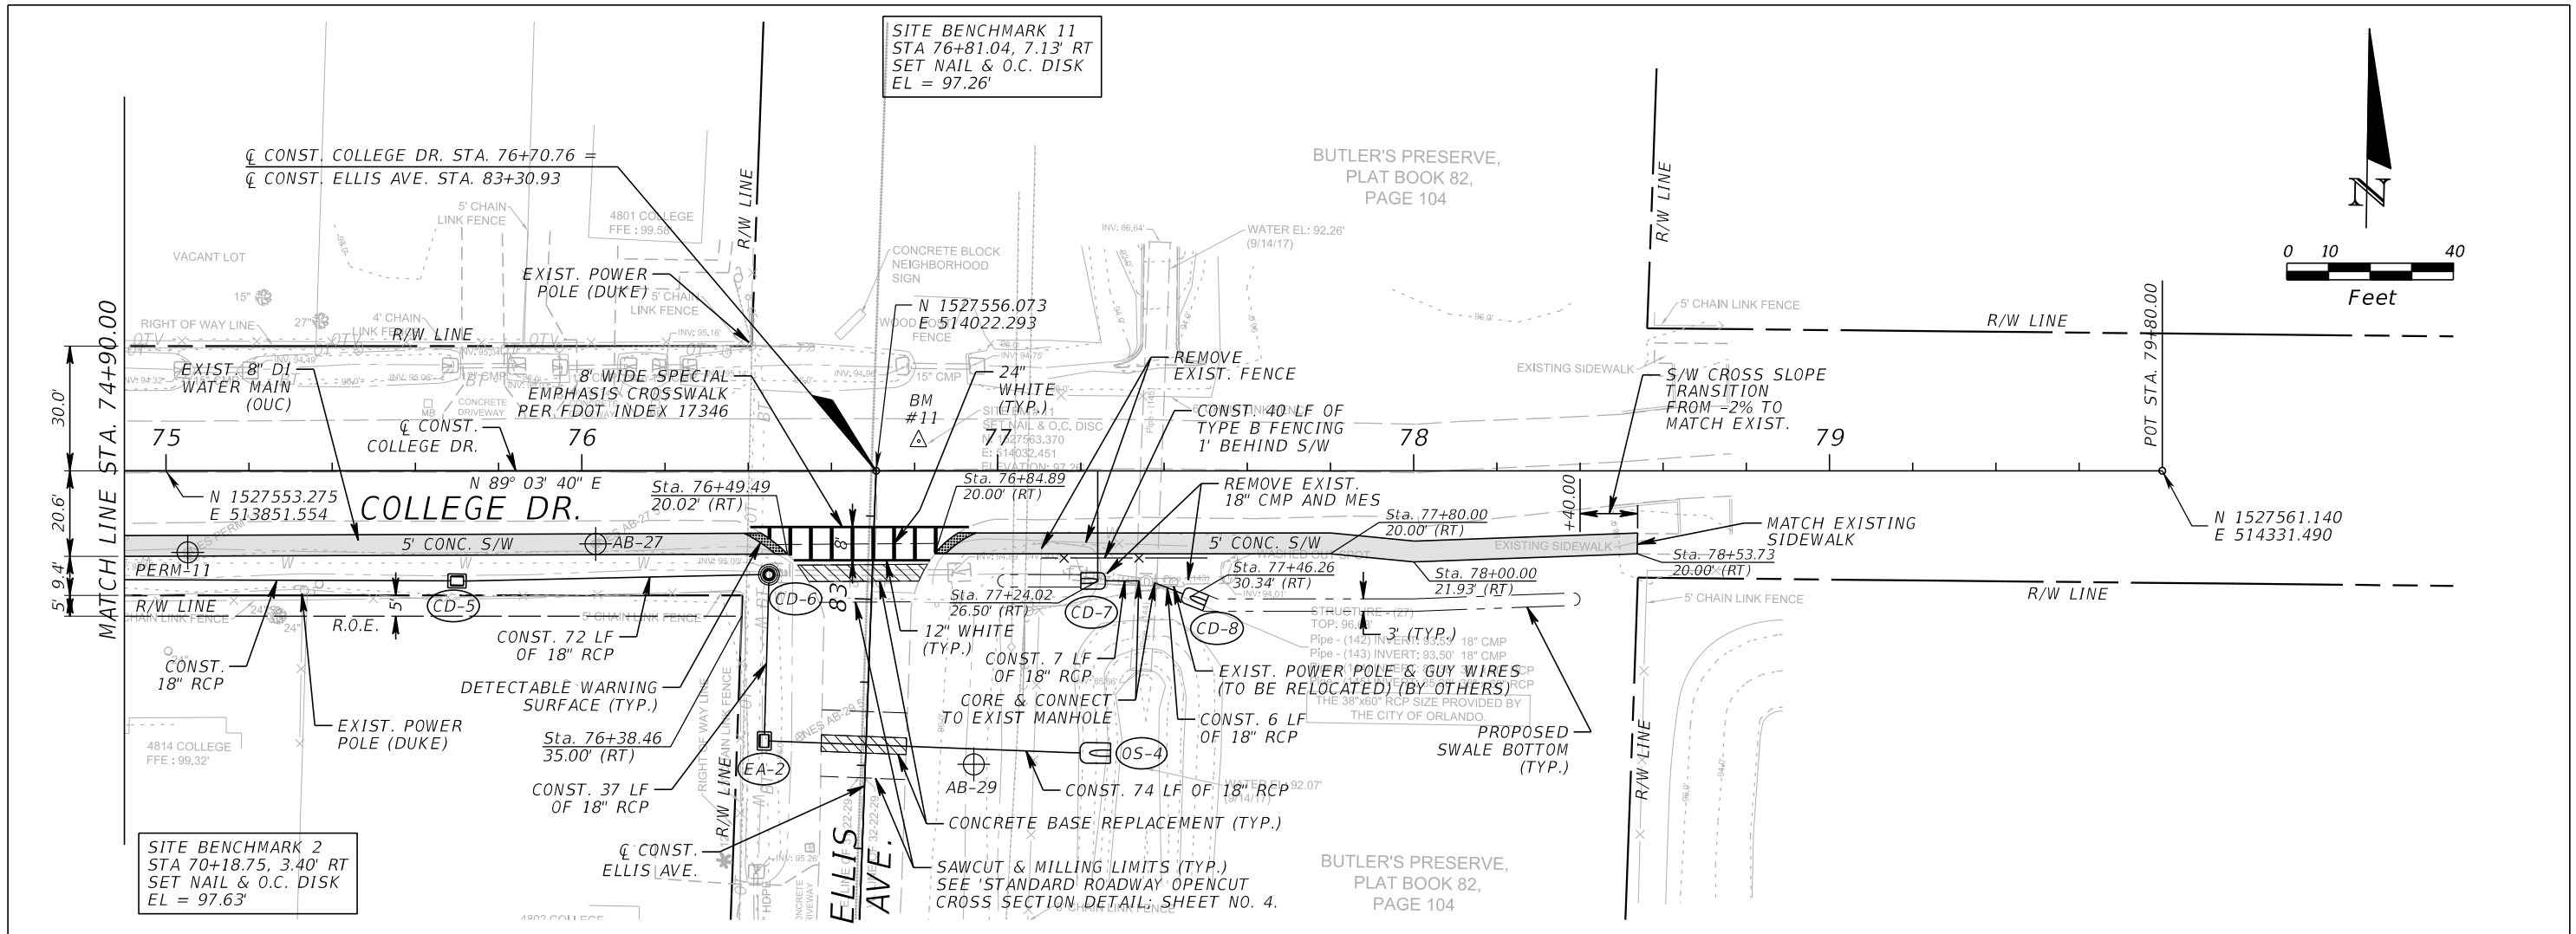

REVISIONS			
DATE	DESCRIPTION	DATE	DESCRIPTION

GTC Engineering Corporation
 98 South Semoran Blvd, Orlando, FL 32807
 Phone Number - 407.380.0402

ORANGE COUNTY PUBLIC WORKS



GTC PROJECT NO. FLO 23.02
 OCPW PROJECT NO. 0193

Certificate of Authorization Number 6758
 Claude L. Cassagnol, P.E. P.E. Number 35490

COLLEGE DR.
PLAN AND PROFILE
STA. 74+90.00 TO STA. 78+53.73

SHEET NO. 31

FILE: H:\Jobs\FLO23.02-LittleEgypt\roadway\PLPRRD2.dgn
 DATE: 2/16/2018 8:40:41 AM

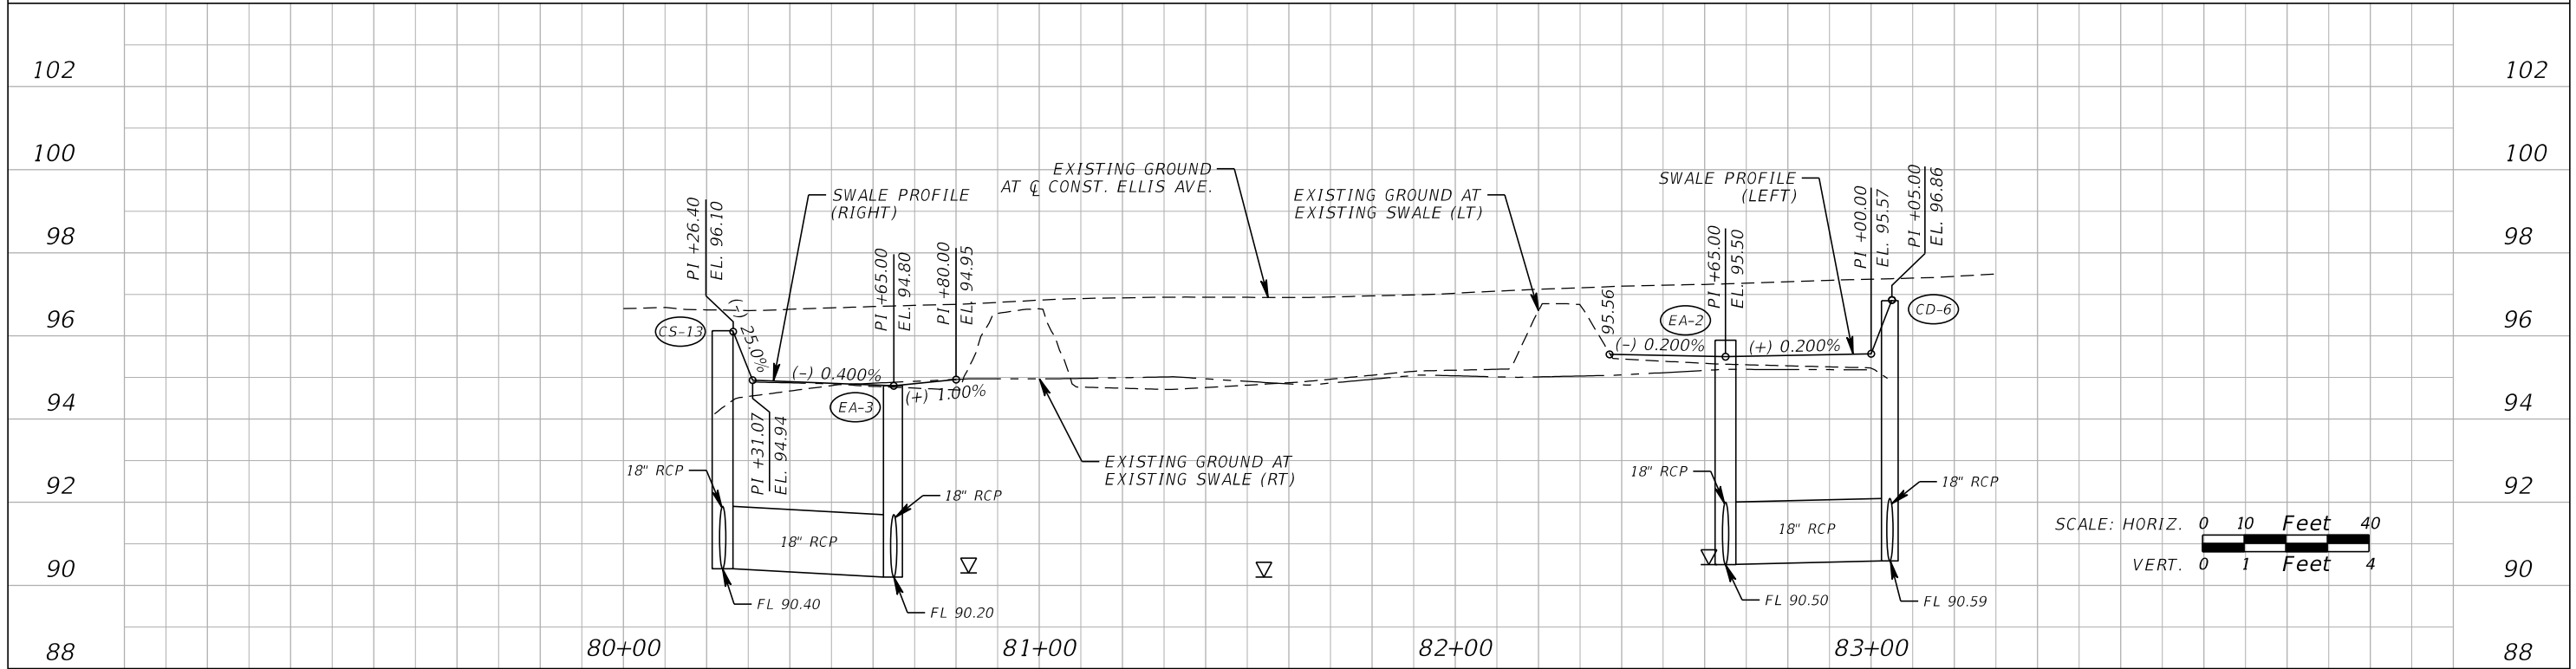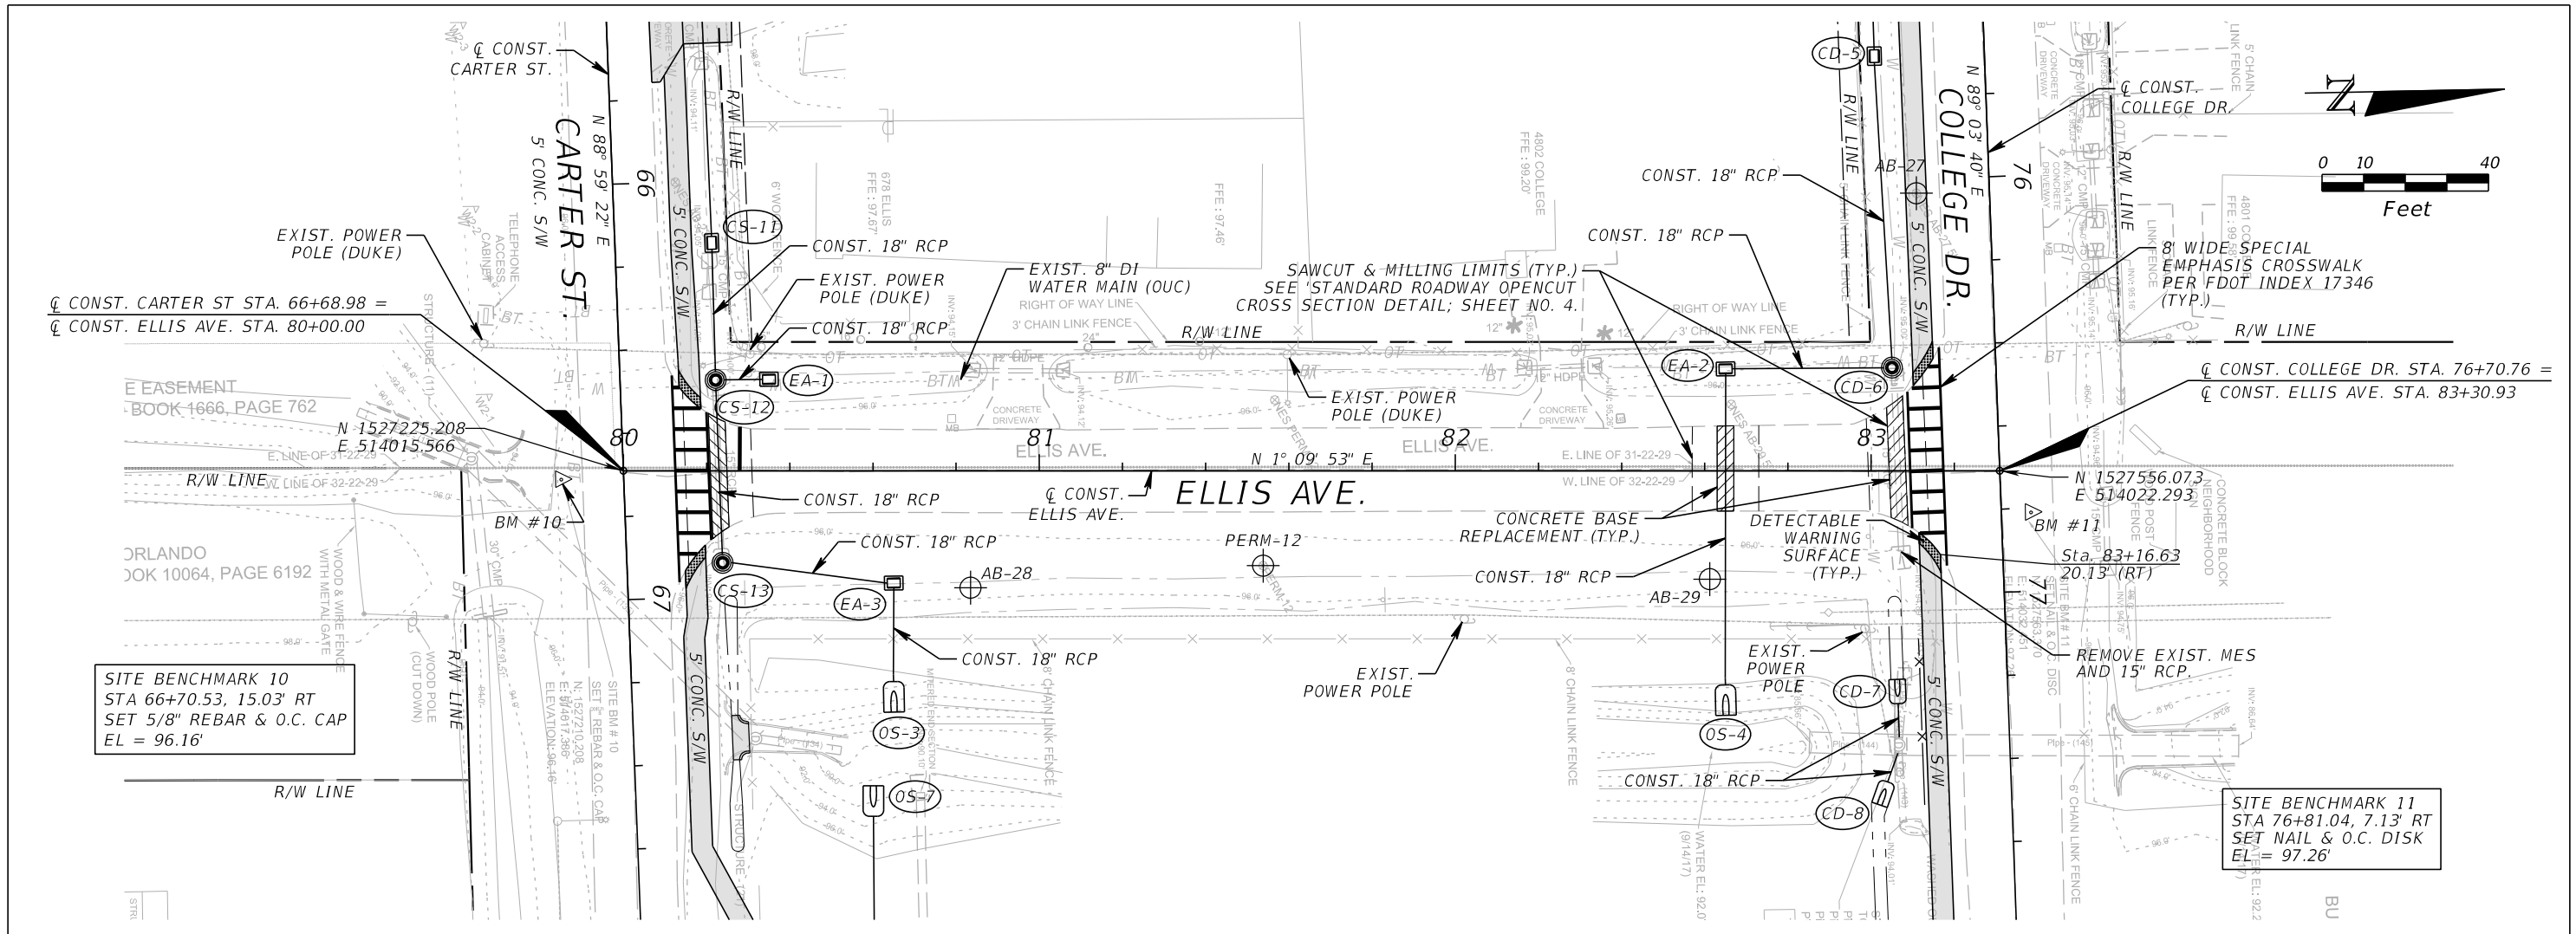

REVISIONS		DESCRIPTION	
DATE	DESCRIPTION	DATE	DESCRIPTION

GTC Engineering Corporation
 98 South Semoran Blvd, Orlando, FL 32807
 Phone Number - 407.380.0402





ORANGE COUNTY PUBLIC WORKS

GTC PROJECT NO.	LITTLE EGYPT SIDEWALK IMPROVEMENTS	OCPW PROJECT NO.
FLO 23.02		0193

ELLIS AVE.
PLAN AND PROFILE
STA. 80+00.00 TO STA. 83+30.93

SHEET NO. 32

 FILE: H:\Jobs\FLO23.02-LittleEgypt\roadway\PLPRD13.dgn
 DATE: 5/8/2018 9:40:28 AM

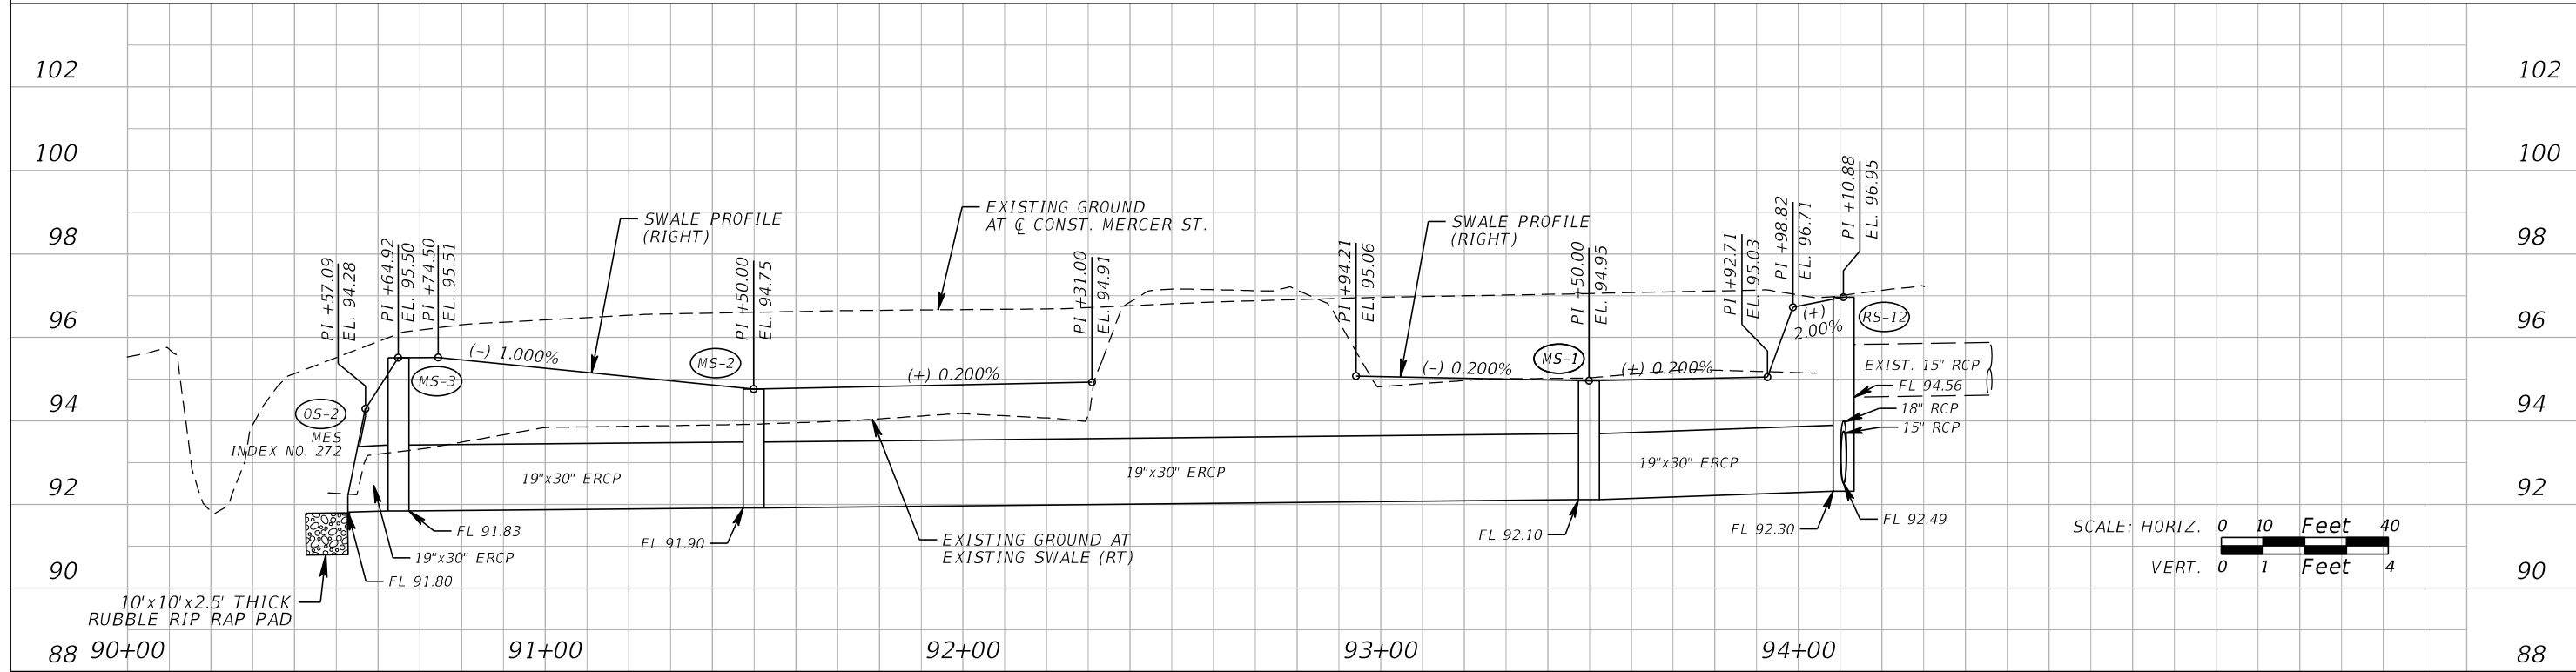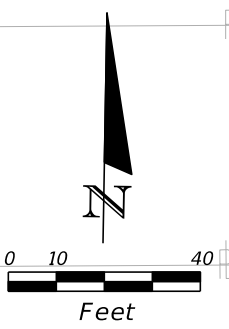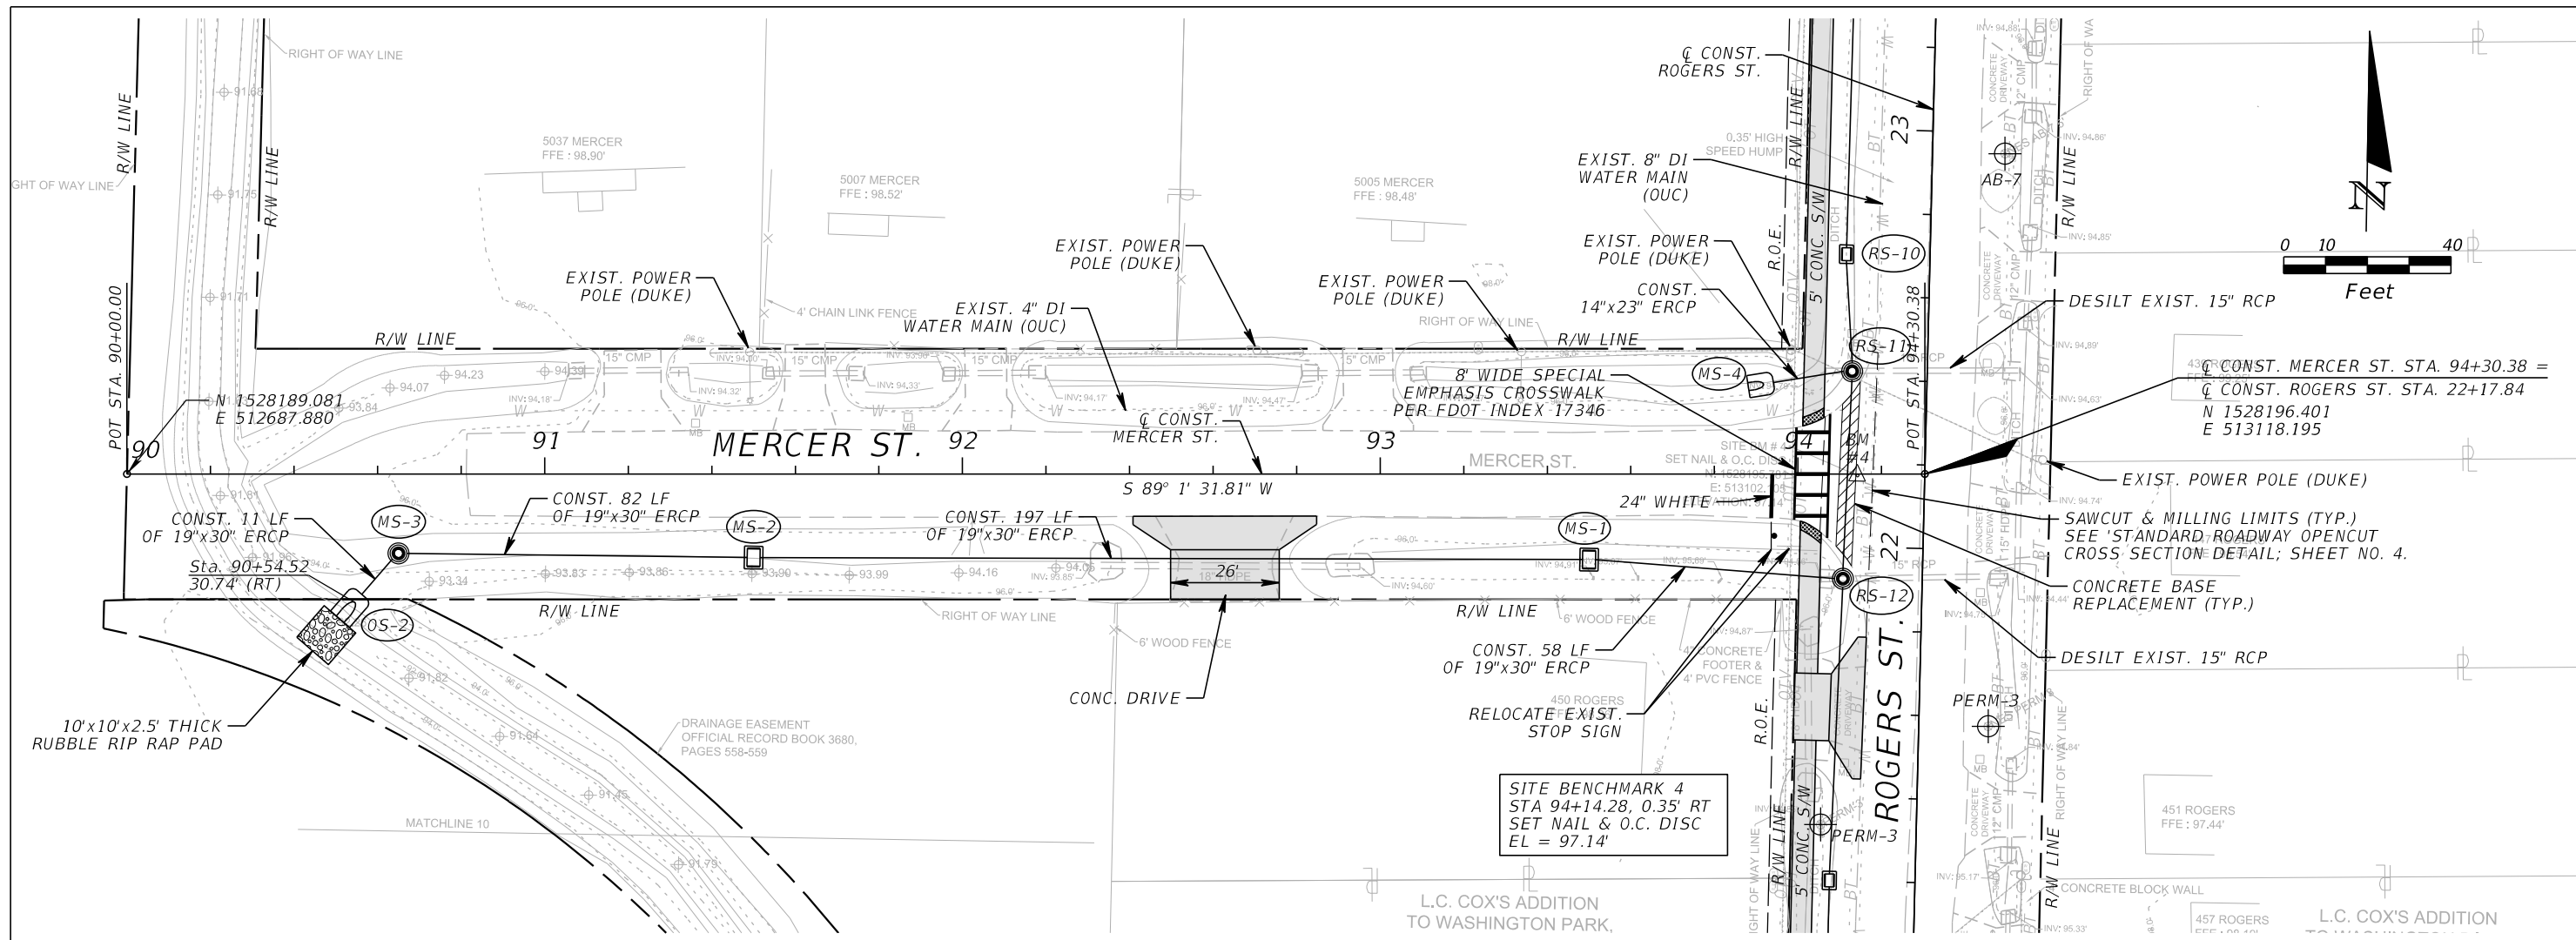

REVISIONS			
DATE	DESCRIPTION	DATE	DESCRIPTION

GTC Engineering Corporation
 98 South Semoran Blvd, Orlando, FL 32807
 Phone Number - 407.380.0402
 Certificate of Authorization Number 6758
 Claude L. Cassagnol, P.E.
 P.E. Number 35490


ORANGE COUNTY PUBLIC WORKS
 GTC PROJECT NO. FLO 23.02
 LITTLE EGYPT SIDEWALK IMPROVEMENTS
 OCPW PROJECT NO. 0193

MERCER ST.
PLAN AND PROFILE
STA. 90+00.00 TO STA. 94+30.38

SHEET NO. 33

FILE: H:\Jobs\FLO23.02-LittleEgypt\roadway\PLPRRD4.dgn
 DATE: 5/8/2018 2:43:06 PM

NOTE:
ALL UTILITIES THAT ARE IN CONFLICT WILL
BE RELOCATED OR REMOVED BY OTHERS IN
COORDINATION WITH THE CONTRACTOR.

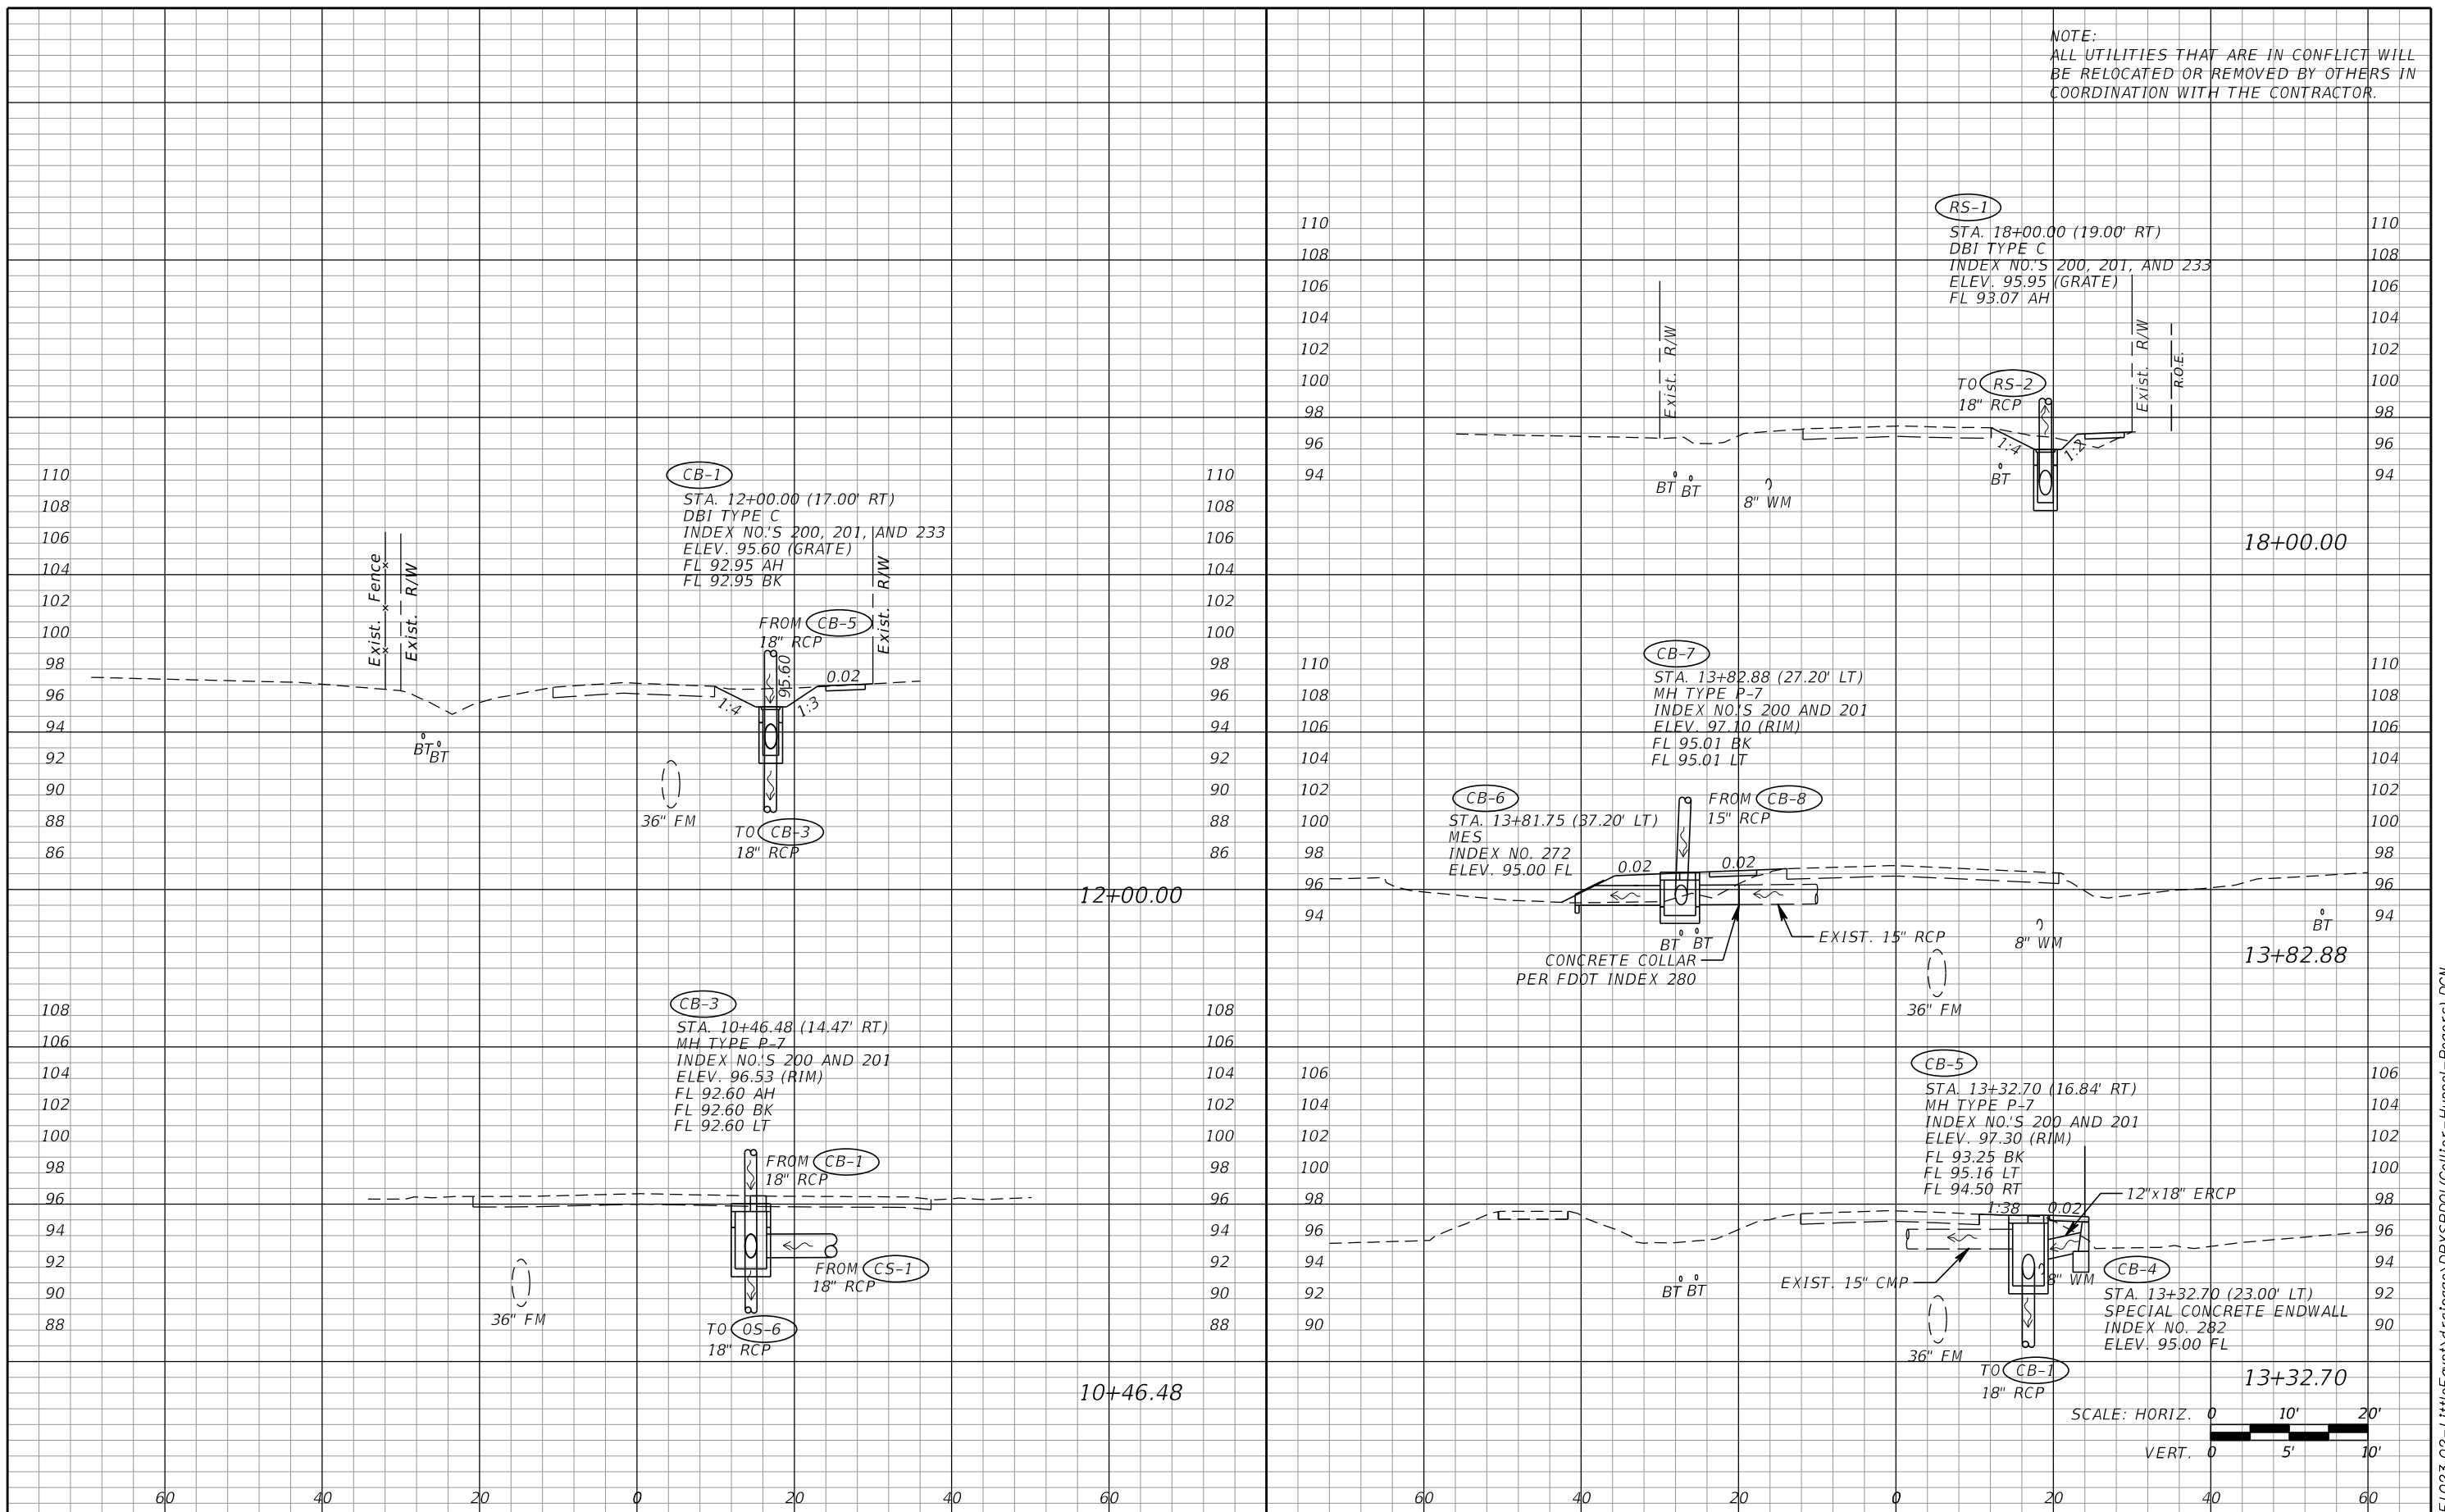

REVISIONS			
DATE	DESCRIPTION	DATE	DESCRIPTION

GTC Engineering Corporation
98 South Semoran Blvd, Orlando, FL 32807
Phone Number - 407.380.0402
Certificate of Authorization Number 6758
Claude L. Cassagnol, P.E.
P.E. Number 35490

ORANGE COUNTY PUBLIC WORKS
GTC PROJECT NO. FLO 23.02
LITTLE EGYPT SIDEWALK IMPROVEMENTS
OCPW PROJECT NO. 0193

**COLLIER BLVD, HUPPEL AVE.
& ROGERS ST.
DRAINAGE STRUCTURE SHEET**
SHEET NO. 34

FILE: H:\Jobs\FLO23.02-LittleEgypt\drainage\DRXSRD01 (Collier-Huppel-Rogers).DGN
DATE: 2/16/2018 11:39:13 AM